


SMALL SPS SCA PANEL (TYPICAL) ELECTRICAL SCHEMATIC

REV: 0

DRAWING SCHEDULE

DRAWING	DESCRIPTION
23557-00	COVERSHEET
23557-01	SINGLE LINE DIAGRAM
23557-02	415VAC DISTRIBUTION
23557-03	415VAC DISTRIBUTION
23557-04	415VAC DISTRIBUTION
23557-05	CONTROLS
23557-06	PUMP CONTROLS
23557-07	PLC HMI OVERVIEW
23557-08	PLC DIGITAL INPUT
23557-09	PLC DIGITAL OUTPUT
23557-10	RTU DIGITAL INPUT / ANALOG INPUT
23557-11	RTU DIGITAL OUTPUT / ANALOG OUTPUT
23557-12	TERMINAL STRIP
23557-13	CONTROL PANEL
23557-14	CONTROL PANEL
23557-15	EQUIPMENT LIST

SYMBOL LEGEND

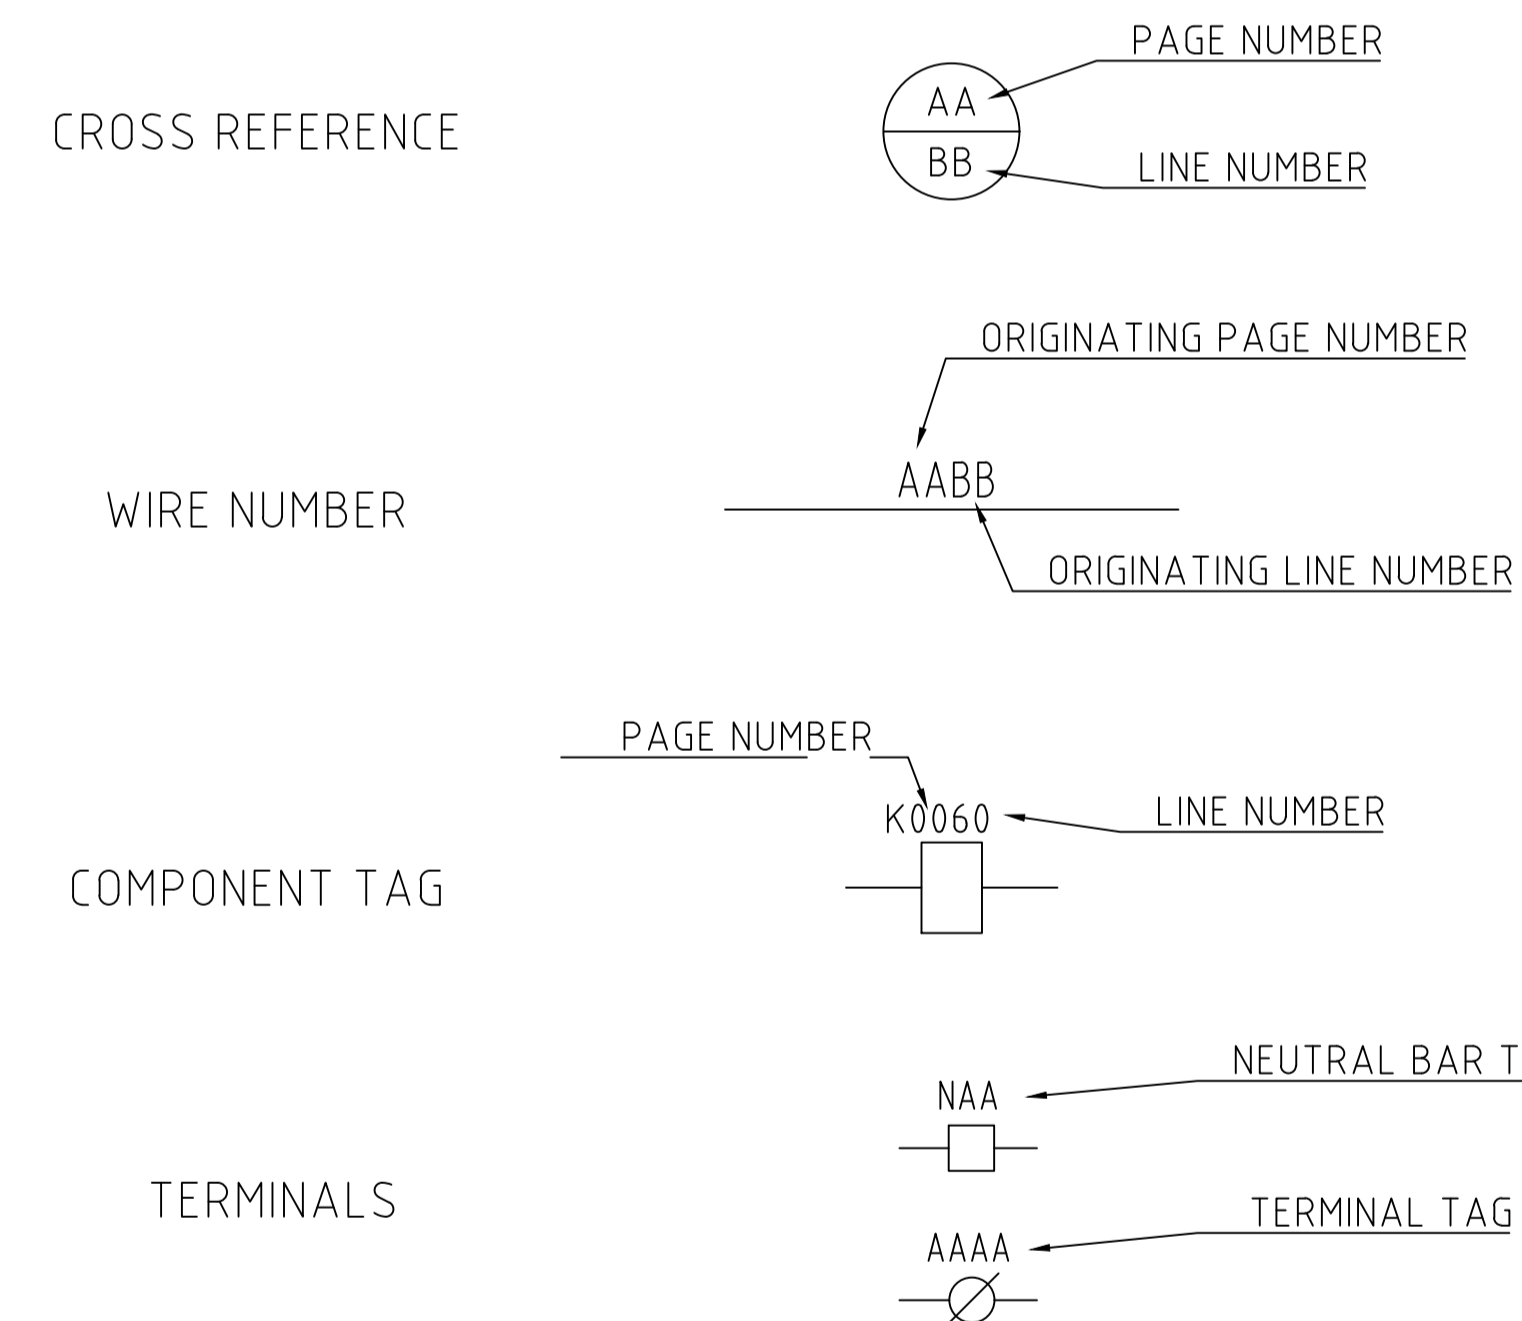

CABLE COLOURS	
Phases:	Red/White/Blue
Neutral:	Black
240VAC:	White
12/24VDC:	Blue&Red Blue&White
12/24VAC:	Brown&Red Brown&White
MINIMUM CABLE SIZES	
Power:	2.5mm ²
Control:	0.75mm ²
Instrumentation:	0.5mm ²

CONSULTANT DETAILS:



City Administrative Centre
PO Box 42, Nowra, NSW 2541
Ph 02 4429 3111
www.shoalwater.nsw.gov.au


SURVEYED:	DATE:	COMPANY:
DESIGNED:	DATE:	COMPANY:
DRAWN:	DATE:	COMPANY:
CHECKED:	DATE:	COMPANY:
APPROVED:	DATE:	COMPANY:

TITLE:
SMALL SPS SCA PANEL (TYPICAL)
ELECTRICAL SCHEMATIC
COVERSHEET

0	ISSUED FOR REVIEW	GJ	04/06/24
No.	REVISION DETAILS	DWN	DATE

SIZE:	SCALE FACTOR:	CO-ORDINATE SYSTEM:	MGA 2020 Zone 56
A1	N.T.S.	HEIGHT DATUM:	AHD

TRIM REFERENCE No.	INDEX No.	DRAWING No.	SHEET	REV No.
47662E	23557	00	00	0

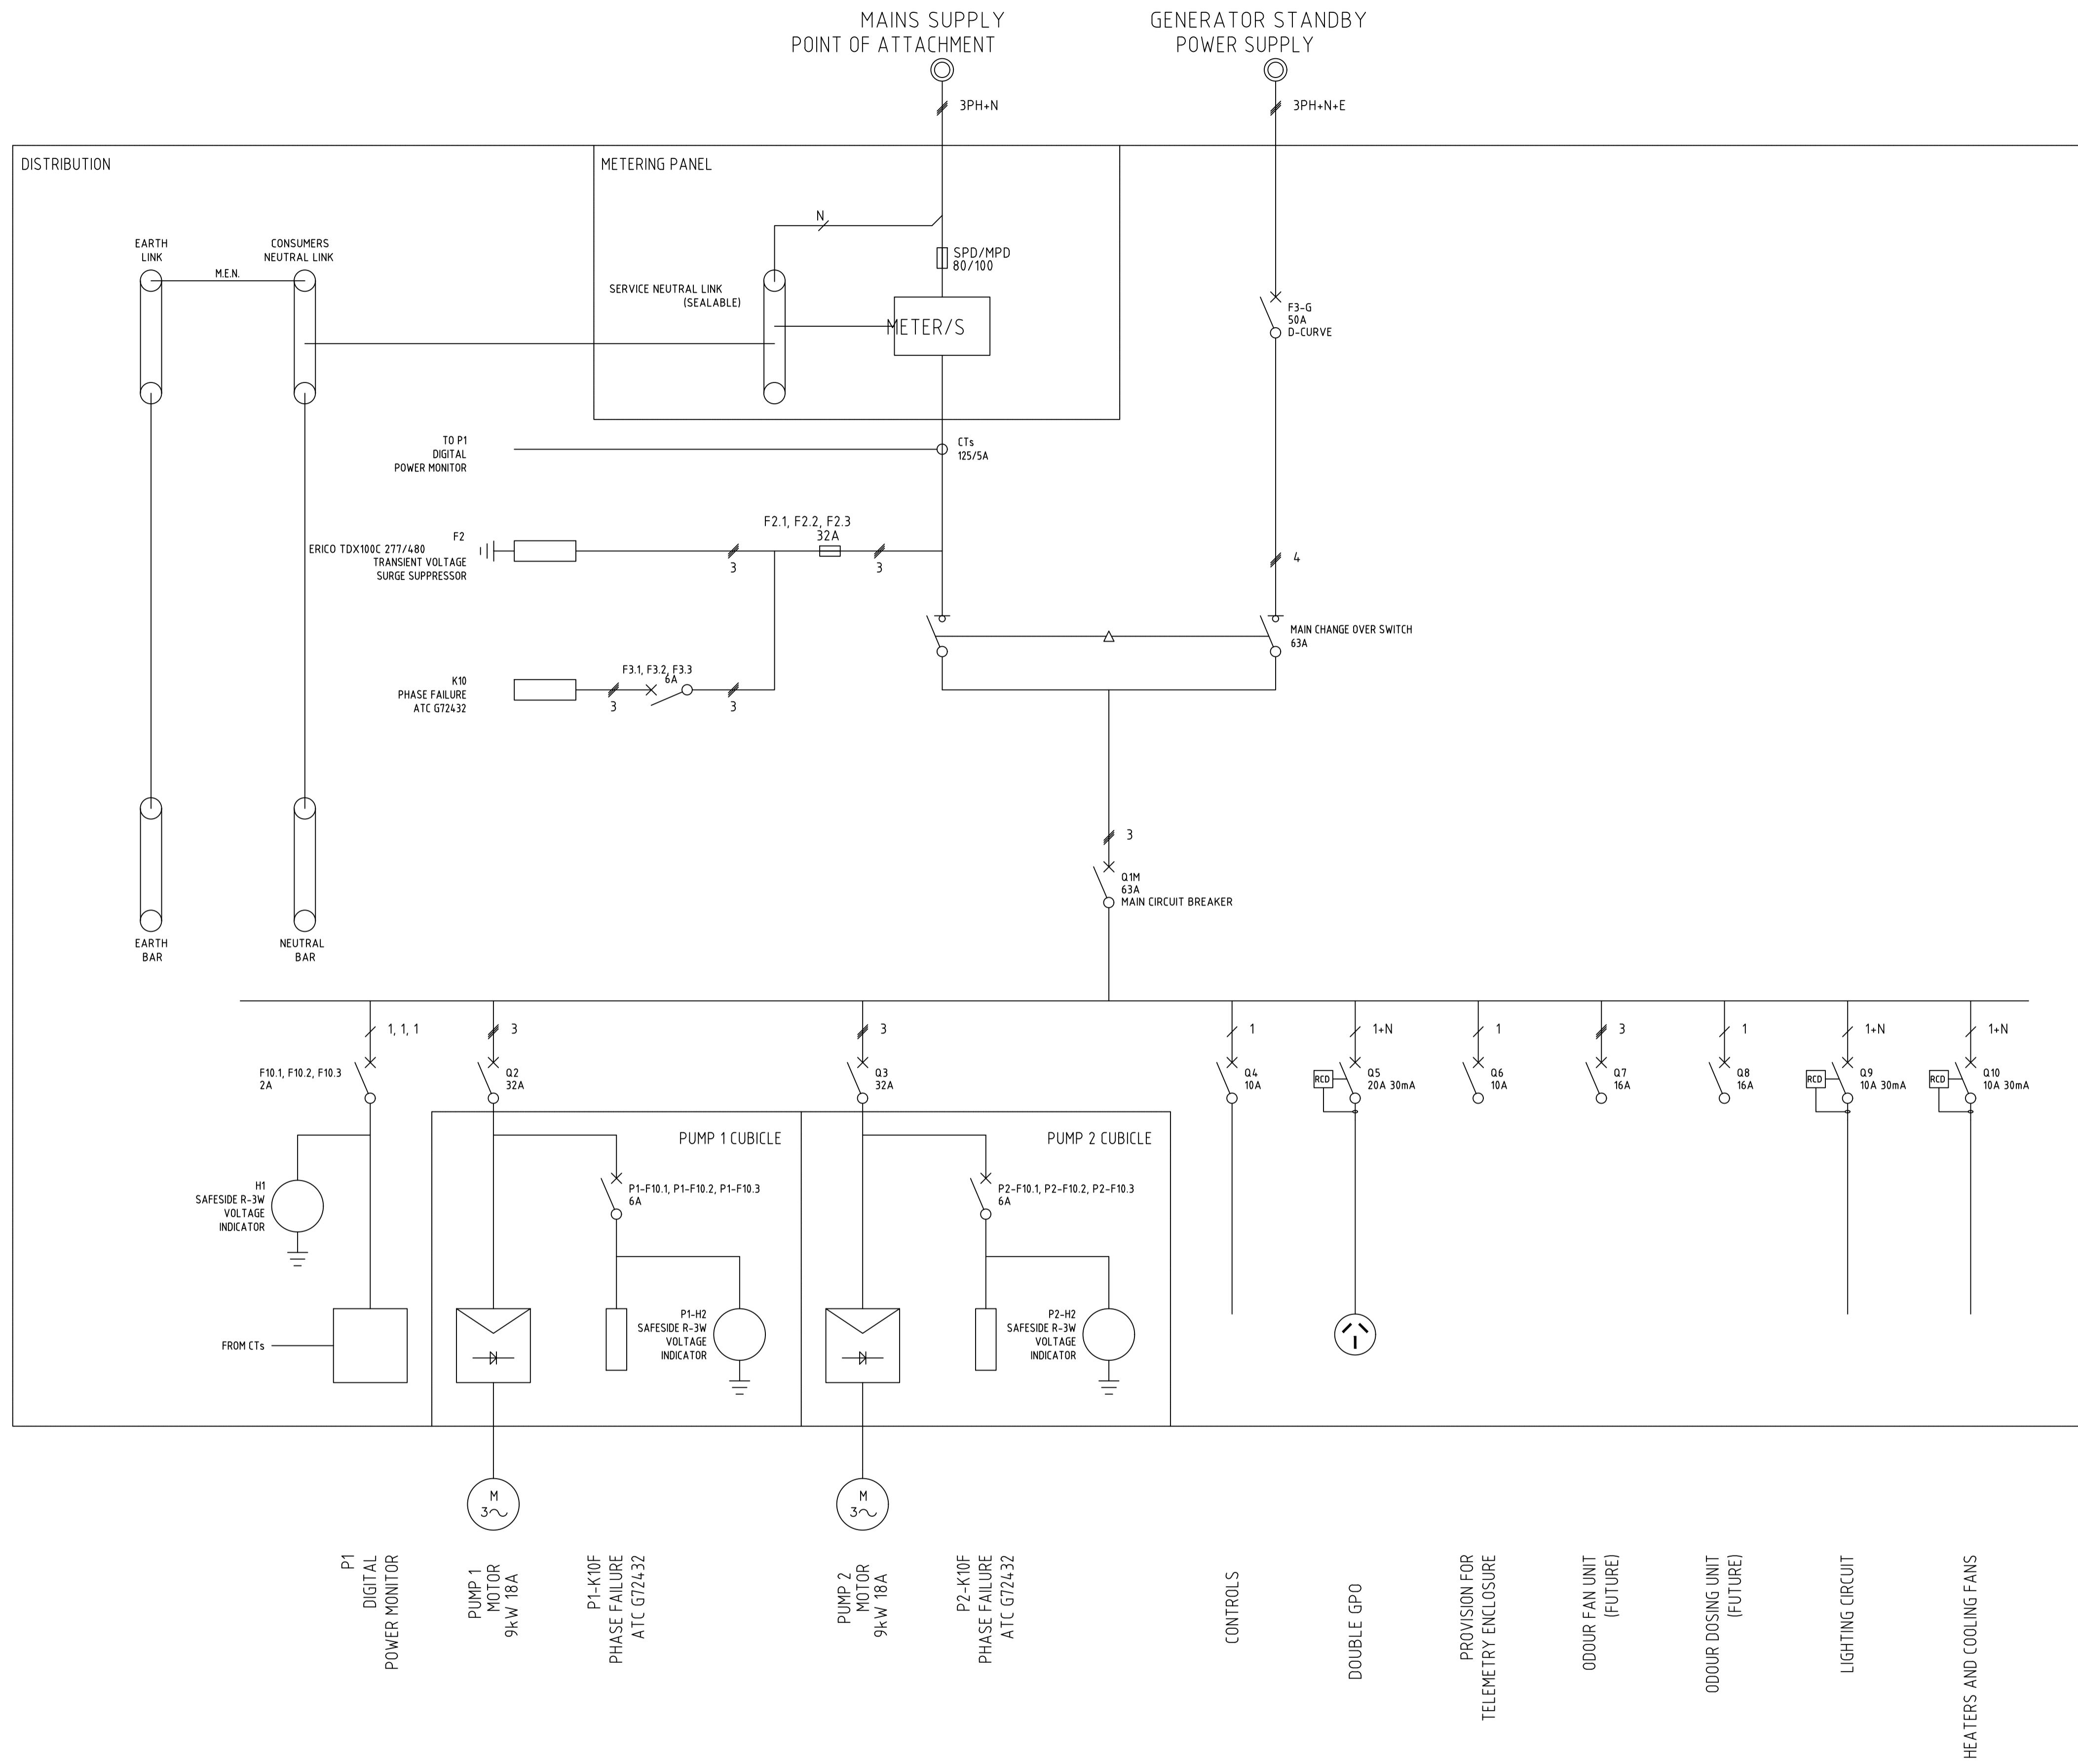

No.	REVISION DETAILS	DWN	DATE
0	ISSUED FOR REVIEW	GJ	04/06/24


CONSULTANT DETAILS:			
SIZE:	SCALE FACTOR:	CO-ORDINATE SYSTEM:	MGA 2020 Zone 56
A1	N.T.S.	HEIGHT DATUM:	AHD



SURVEYED:	DATE:	COMPANY:
DESIGNED:	DATE:	COMPANY:
DRAWN:	DATE:	COMPANY:
CHECKED:	DATE:	COMPANY:
APPROVED:	DATE:	COMPANY:


TITLE:				
SMALL SPS SCA PANEL (TYPICAL) ELECTRICAL SCHEMATIC SINGLE LINE DIAGRAM				
TRIM REFERENCE No	INDEX No.	DRAWING No.	SHEET	REV No.
47662E	23557	01	01	0

Plotted: 19/09/24 - 13:53 CAD File: C:\Users\grace.johns\OneDrive - Shoalhaven City Council\2. Current Projects\Electrical Drawing Updates - Craig Ellis\uploads to website\47552 - 23557 - SMALL SPS (TYPICAL) SCHEMATICS.dwg

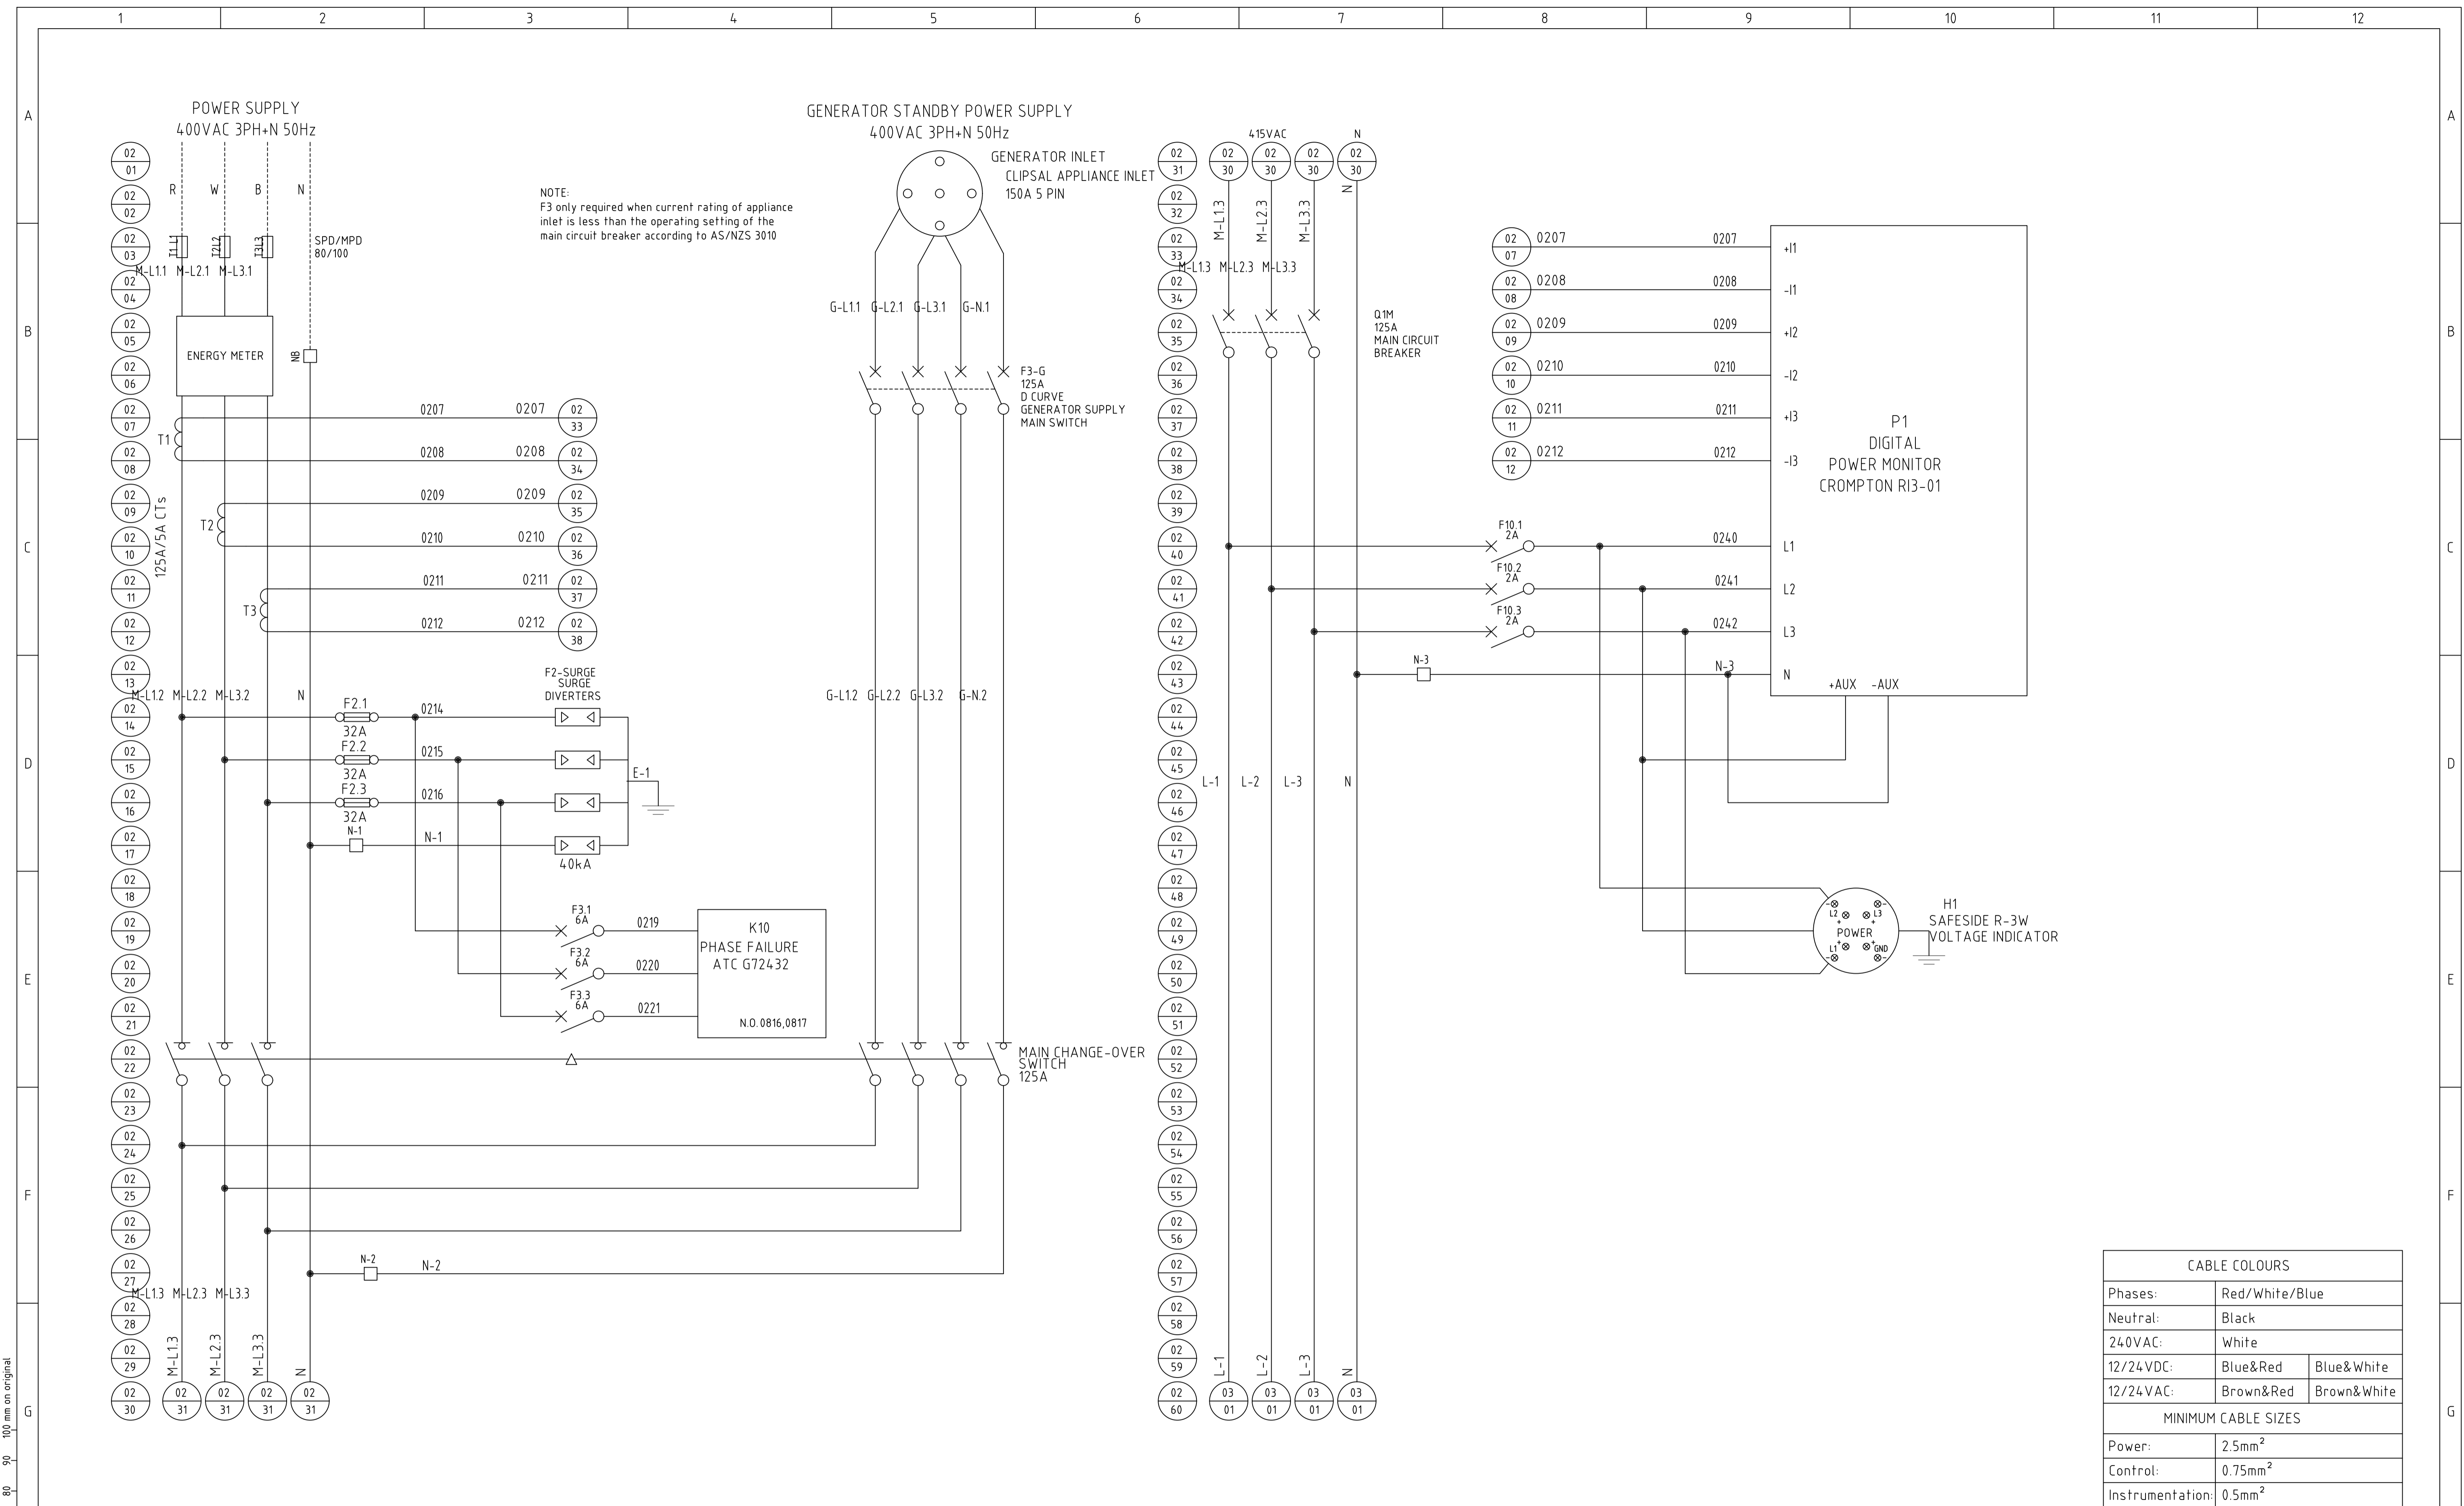


CABLE COLOURS	
Phases:	Red/White/Blue
Neutral:	Black
240VAC:	White
12/24VDC:	Blue&Red Blue&White
12/24VAC:	Brown&Red Brown&White
MINIMUM CABLE SIZES	
Power:	2.5mm ²
Control:	0.75mm ²
Instrumentation:	0.5mm ²

<p>City Administrative Centre PO Box 42, Nowra, NSW 2541 Ph 02 4429 3111 www.shoalwater.nsw.gov.au</p>				SURVEYED: DATE: COMPANY: DESIGNED: CE 15/02/24 SW DRAWN: GJ 04/06/24 SW CHECKED: AR 04/06/24 SW APPROVED: DATE: COMPANY:		TITLE: SMALL SPS SCA PANEL (TYPICAL) ELECTRICAL SCHEMATIC 415VAC DISTRIBUTION	
CONSULTANT DETAILS: 		TRIM REFERENCE No: 47662E INDEX No: 23557		DRAWING No: 02 SHEET: 02 REV No: 0			
0 ISSUED FOR REVIEW GJ 04/06/24		SIZE: A1 SCALE FACTOR: N.T.S. CO-ORDINATE SYSTEM: MGA 2020 Zone 56 HEIGHT DATUM: AHD					
REVISION DETAILS No. 1 2 3 4 5 6 7 8 9 10 11 12							

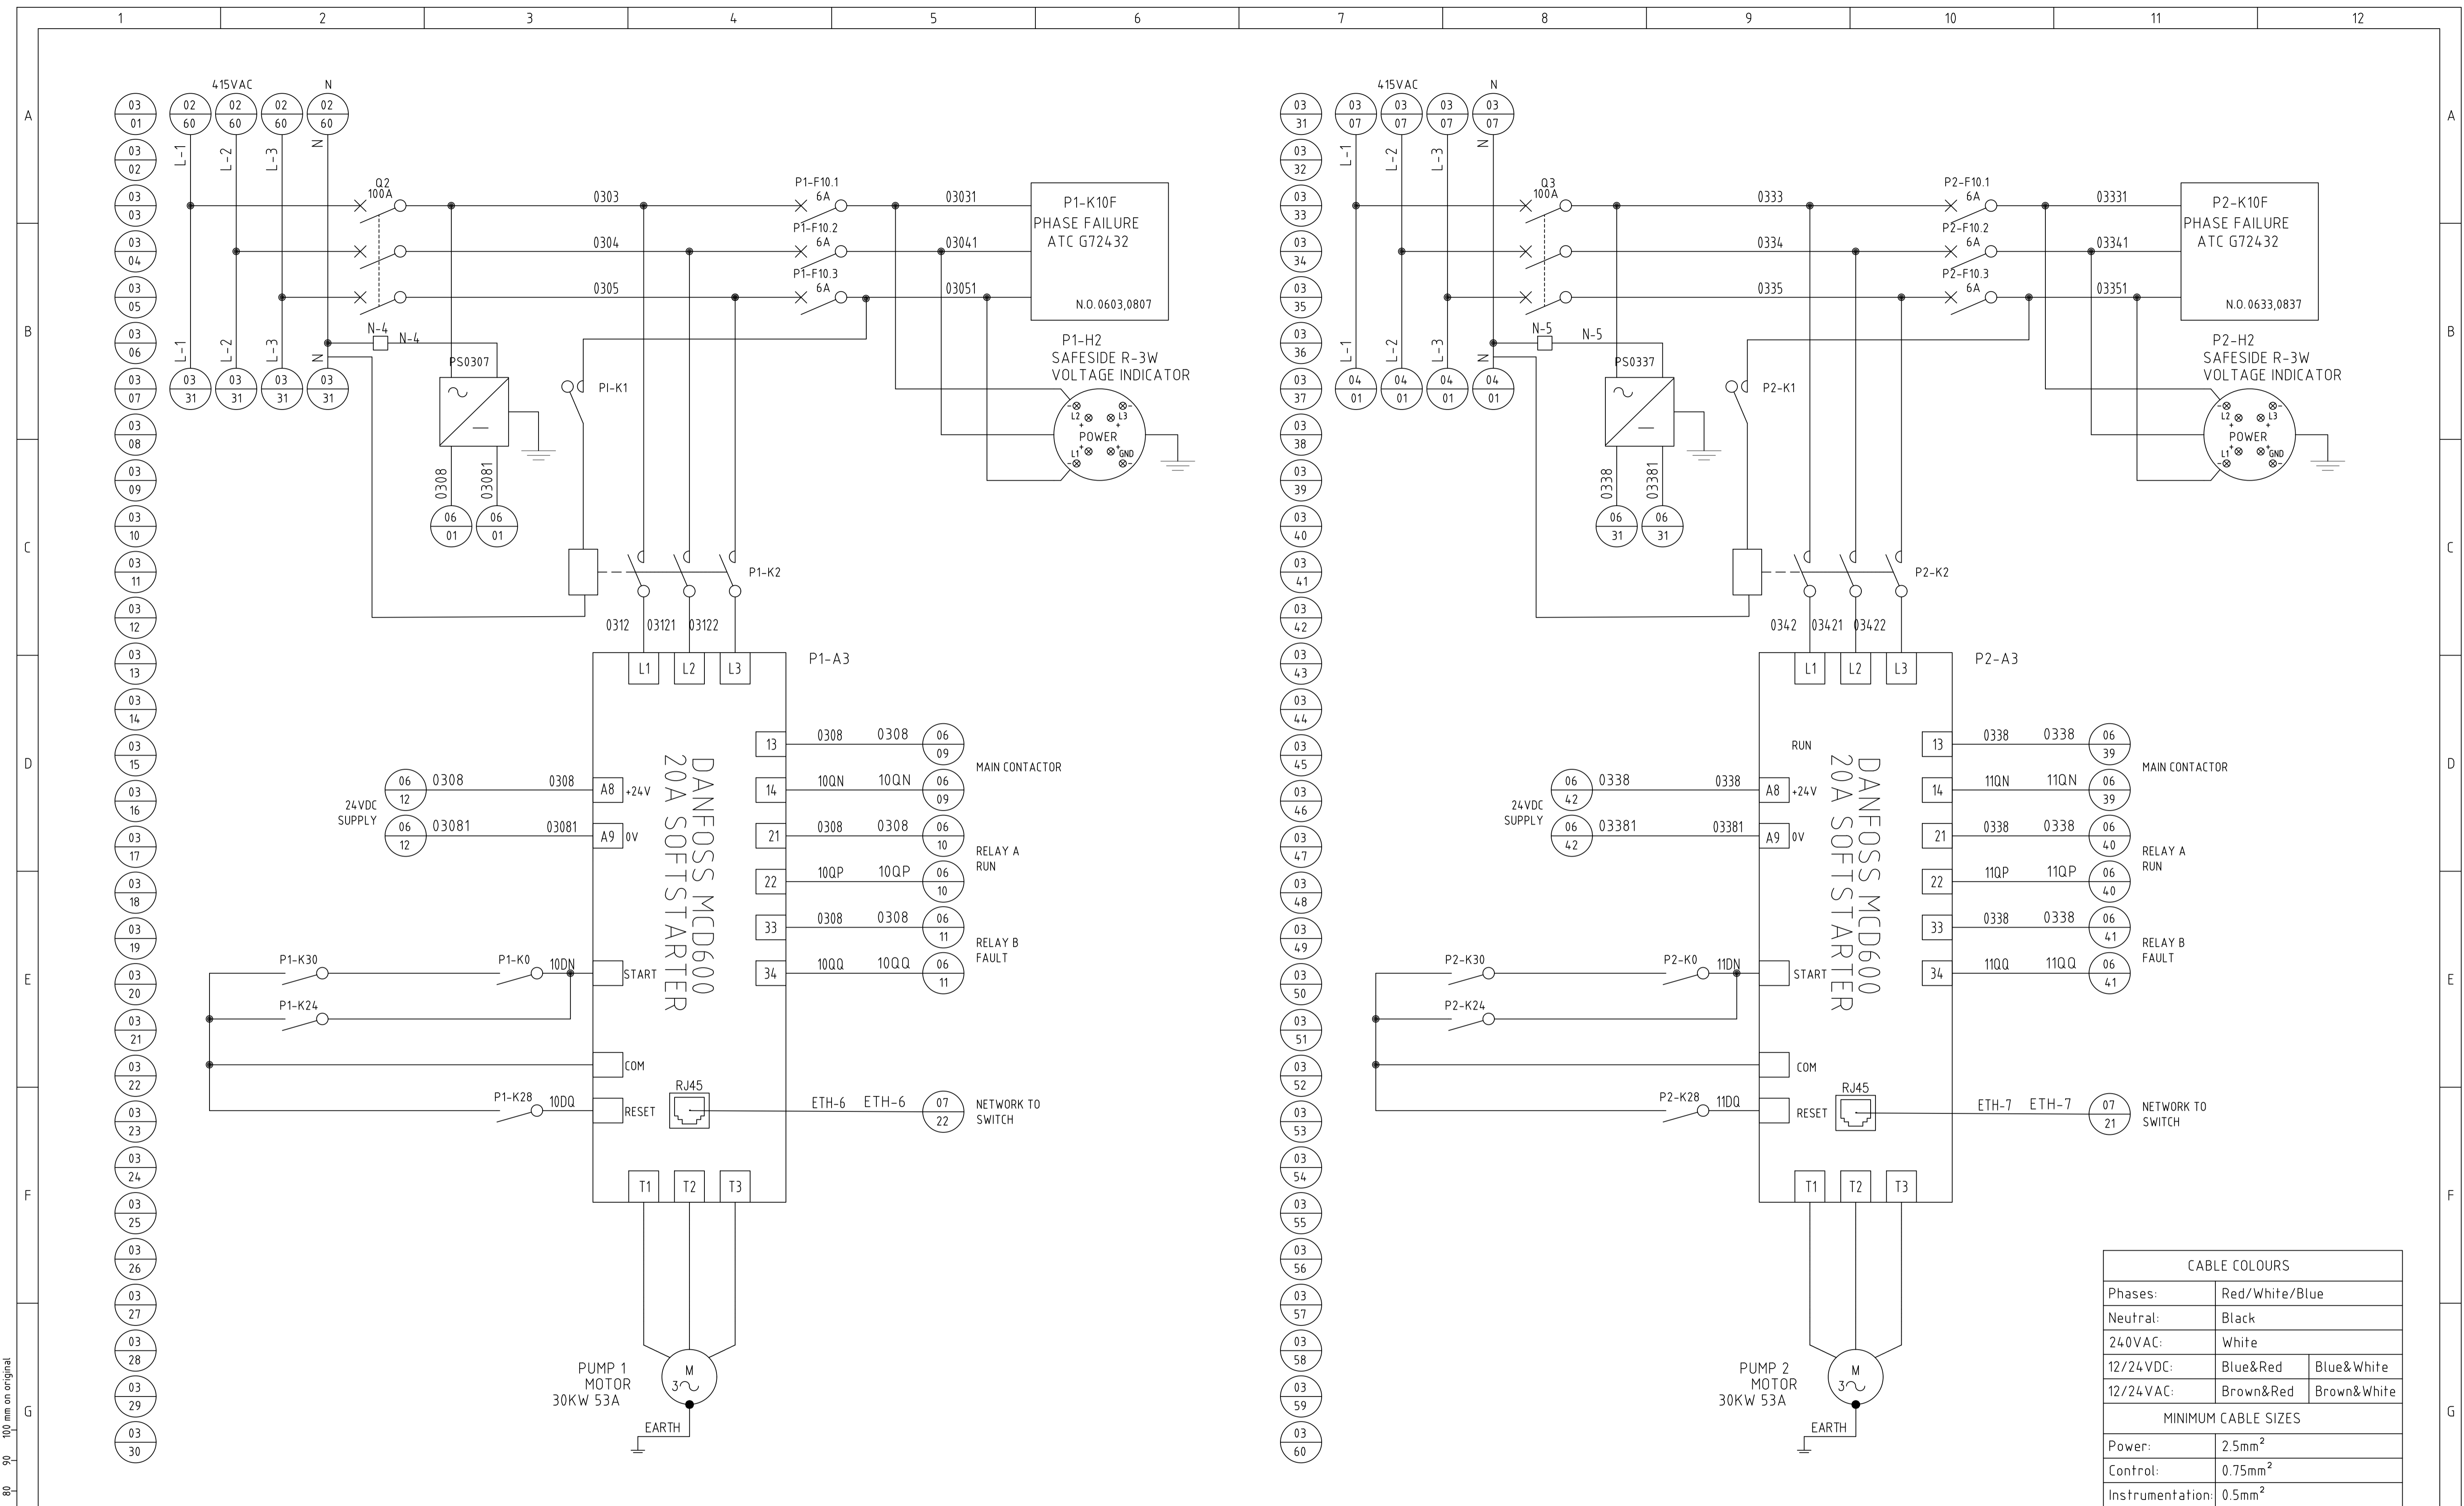

CABLE COLOURS	
Phases:	Red/White/Blue
Neutral:	Black
240VAC:	White
12/24VDC:	Blue&Red Blue&White
12/24VAC:	Brown&Red Brown&White
MINIMUM CABLE SIZES	
Power:	2.5mm ²
Control:	0.75mm ²
Instrumentation:	0.5mm ²


				SURVEYED: DATE: COMPANY: DESIGNED: CE 15/02/24 SW DRAWN: GJ 04/06/24 SW CHECKED: AR 04/06/24 SW APPROVED: DATE: COMPANY:		TITLE: SMALL SPS SCA PANEL (TYPICAL) ELECTRICAL SCHEMATIC 415VAC DISTRIBUTION	
CONSULTANT DETAILS: 				TRIM REFERENCE No: 47662E INDEX No: 23557		DRAWING No: 03 SHEET: 03 REV No: 0	
No. 0 ISSUED FOR REVIEW GJ 04/06/24		SIZE: A1 SCALE FACTOR: N.T.S. CO-ORDINATE SYSTEM: MGA 2020 Zone 56 HEIGHT DATUM: AHD		No. 1 REVISION DETAILS DWN DATE			

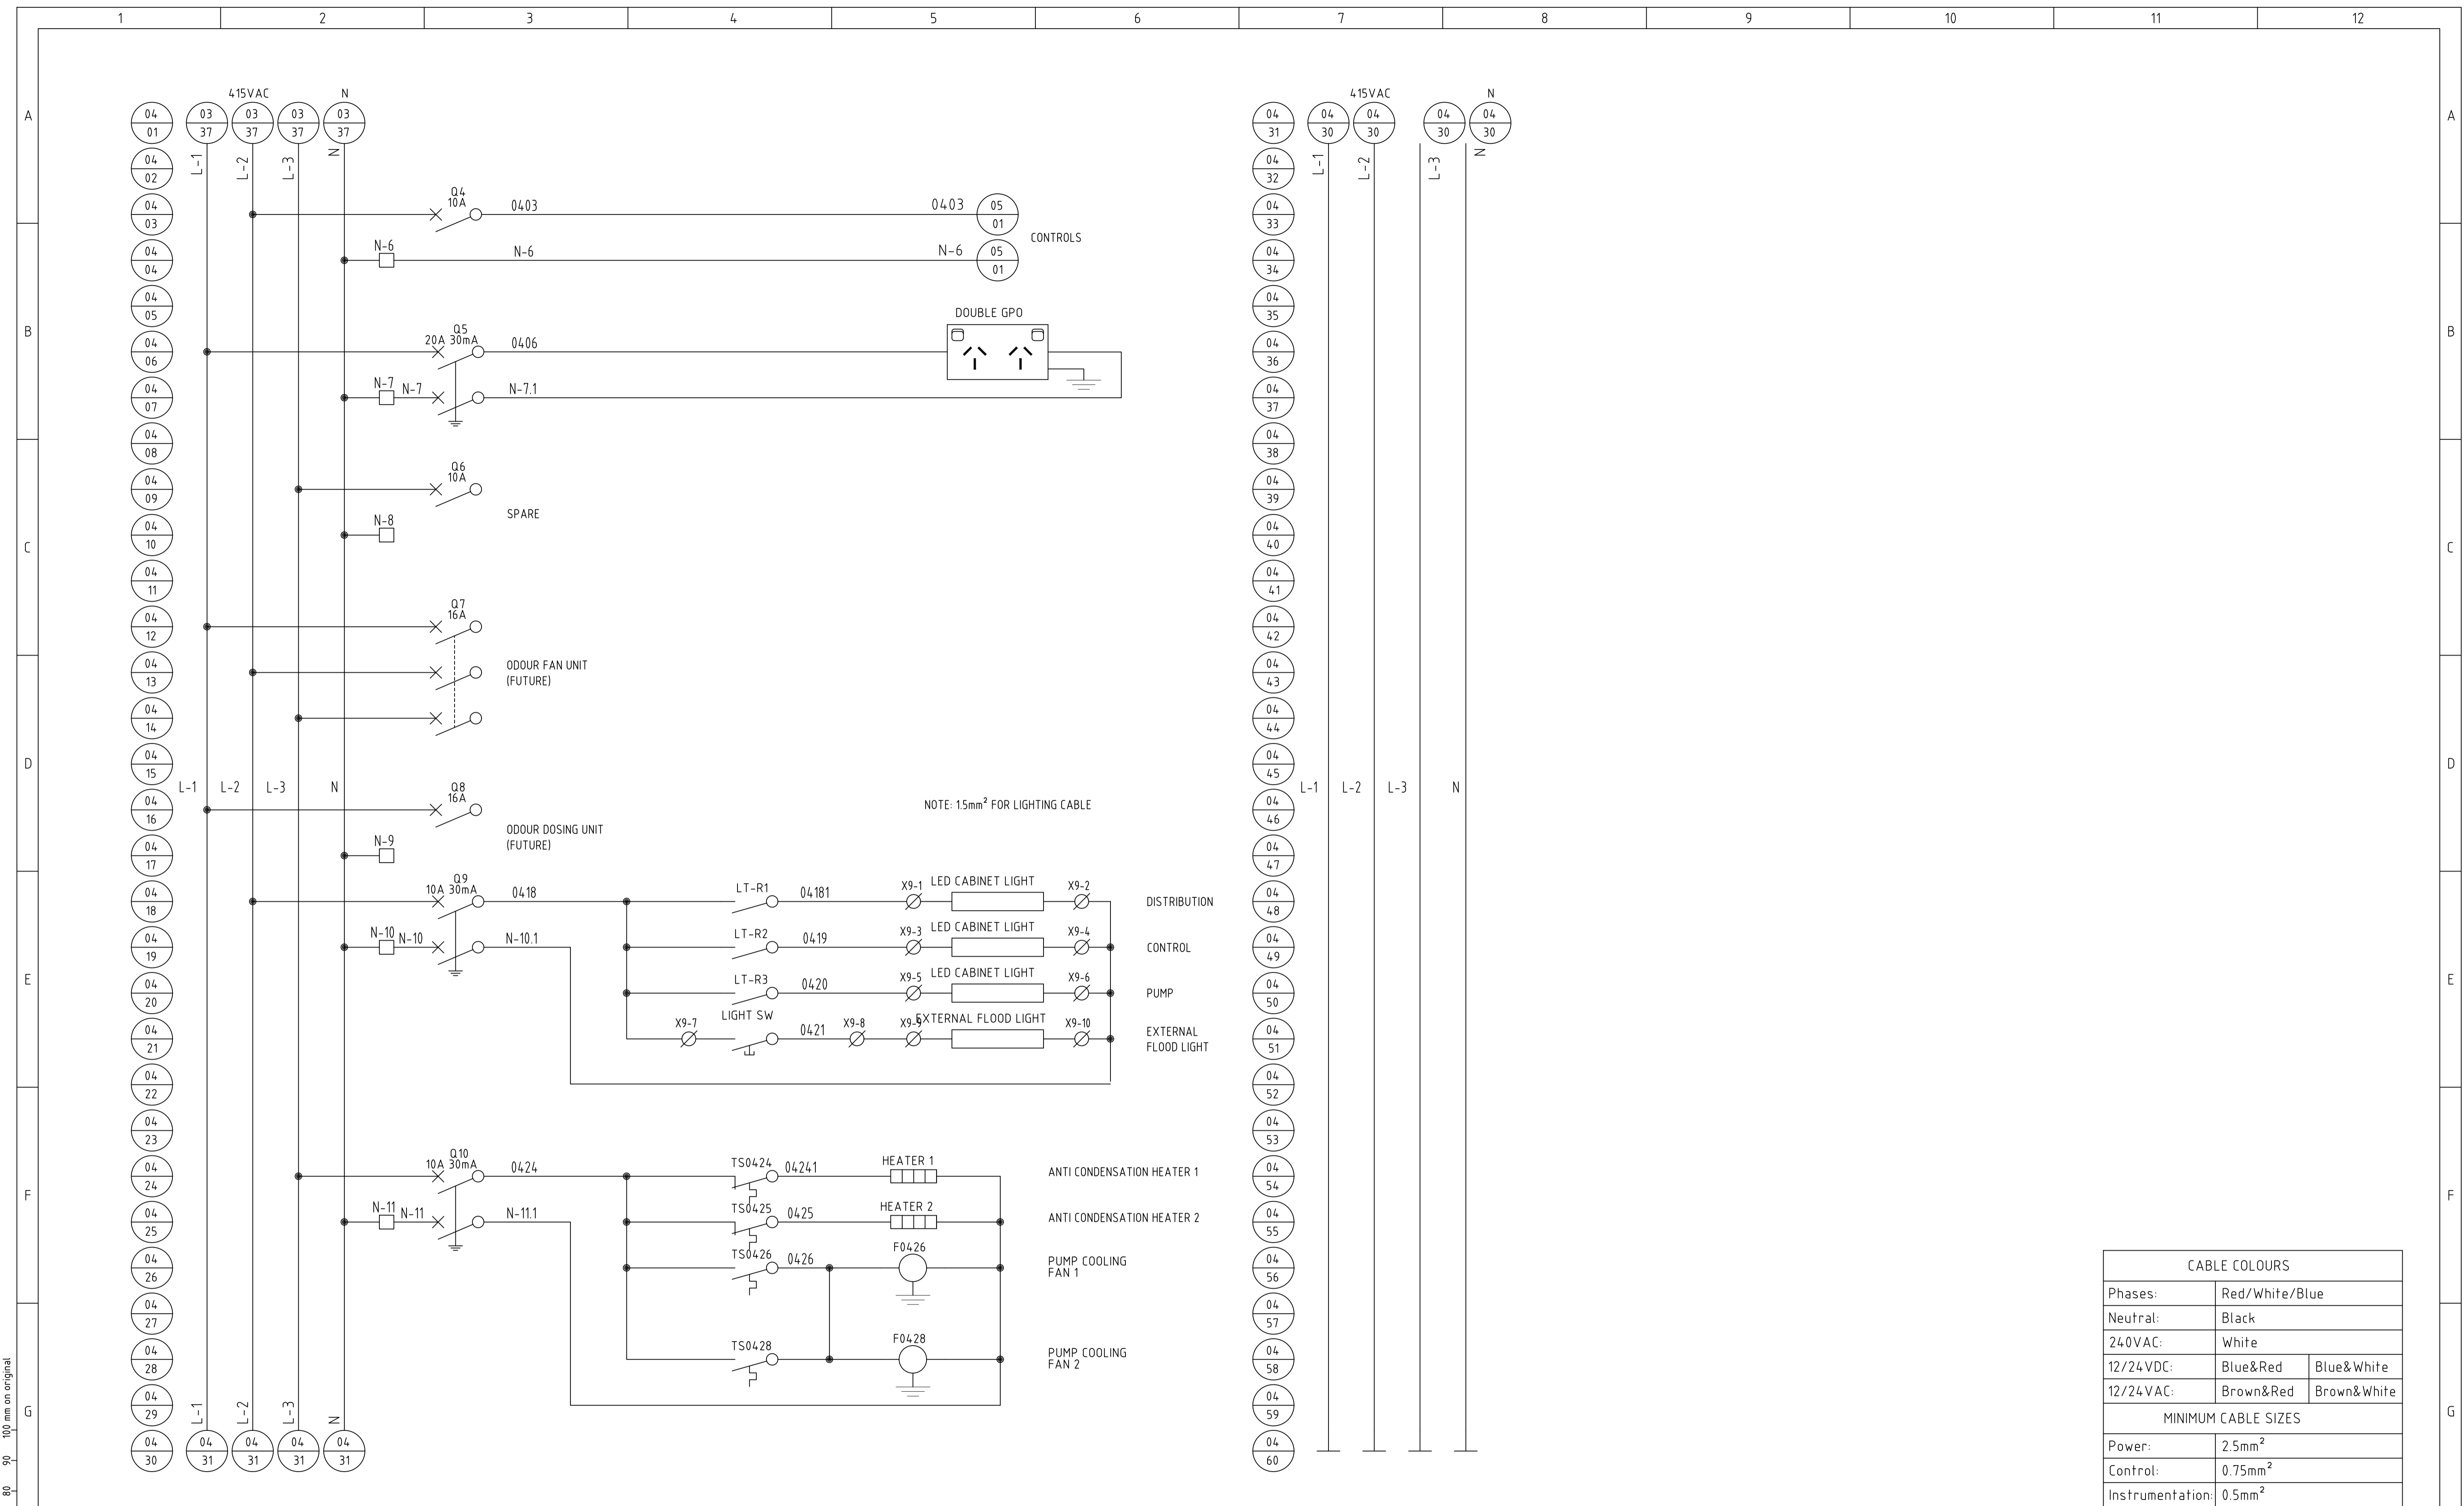

NOTE: 15mm² FOR LIGHTING CABLE

CABLE COLOURS	
Phases:	Red/White/Blue
Neutral:	Black
240VAC:	White
12/24VDC:	Blue&Red Blue&White
12/24VAC:	Brown&Red Brown&White
MINIMUM CABLE SIZES	
Power:	2.5mm ²
Control:	0.75mm ²
Instrumentation:	0.5mm ²


				SURVEYED: DATE: COMPANY:		TITLE: SMALL SPS SCA PANEL (TYPICAL) ELECTRICAL SCHEMATIC 415VAC DISTRIBUTION			
City Administrative Centre PO Box 42, Nowra, NSW 2541 Ph 02 4429 3111 www.shoalwater.nsw.gov.au				DESIGNED: DATE: COMPANY: CE 15/02/24 SW					
				CONSULTANT DETAILS:				DRAWN: DATE: COMPANY: GJ 04/06/24 SW	
CO-ORDINATE SYSTEM: MGA 2020 Zone 56 HEIGHT DATUM: AHD								CHECKED: DATE: COMPANY: AR 04/06/24 SW	
				SCALE FACTOR: N.T.S. SIZE: A1				APPROVED: DATE: COMPANY:	
REVISION DETAILS									

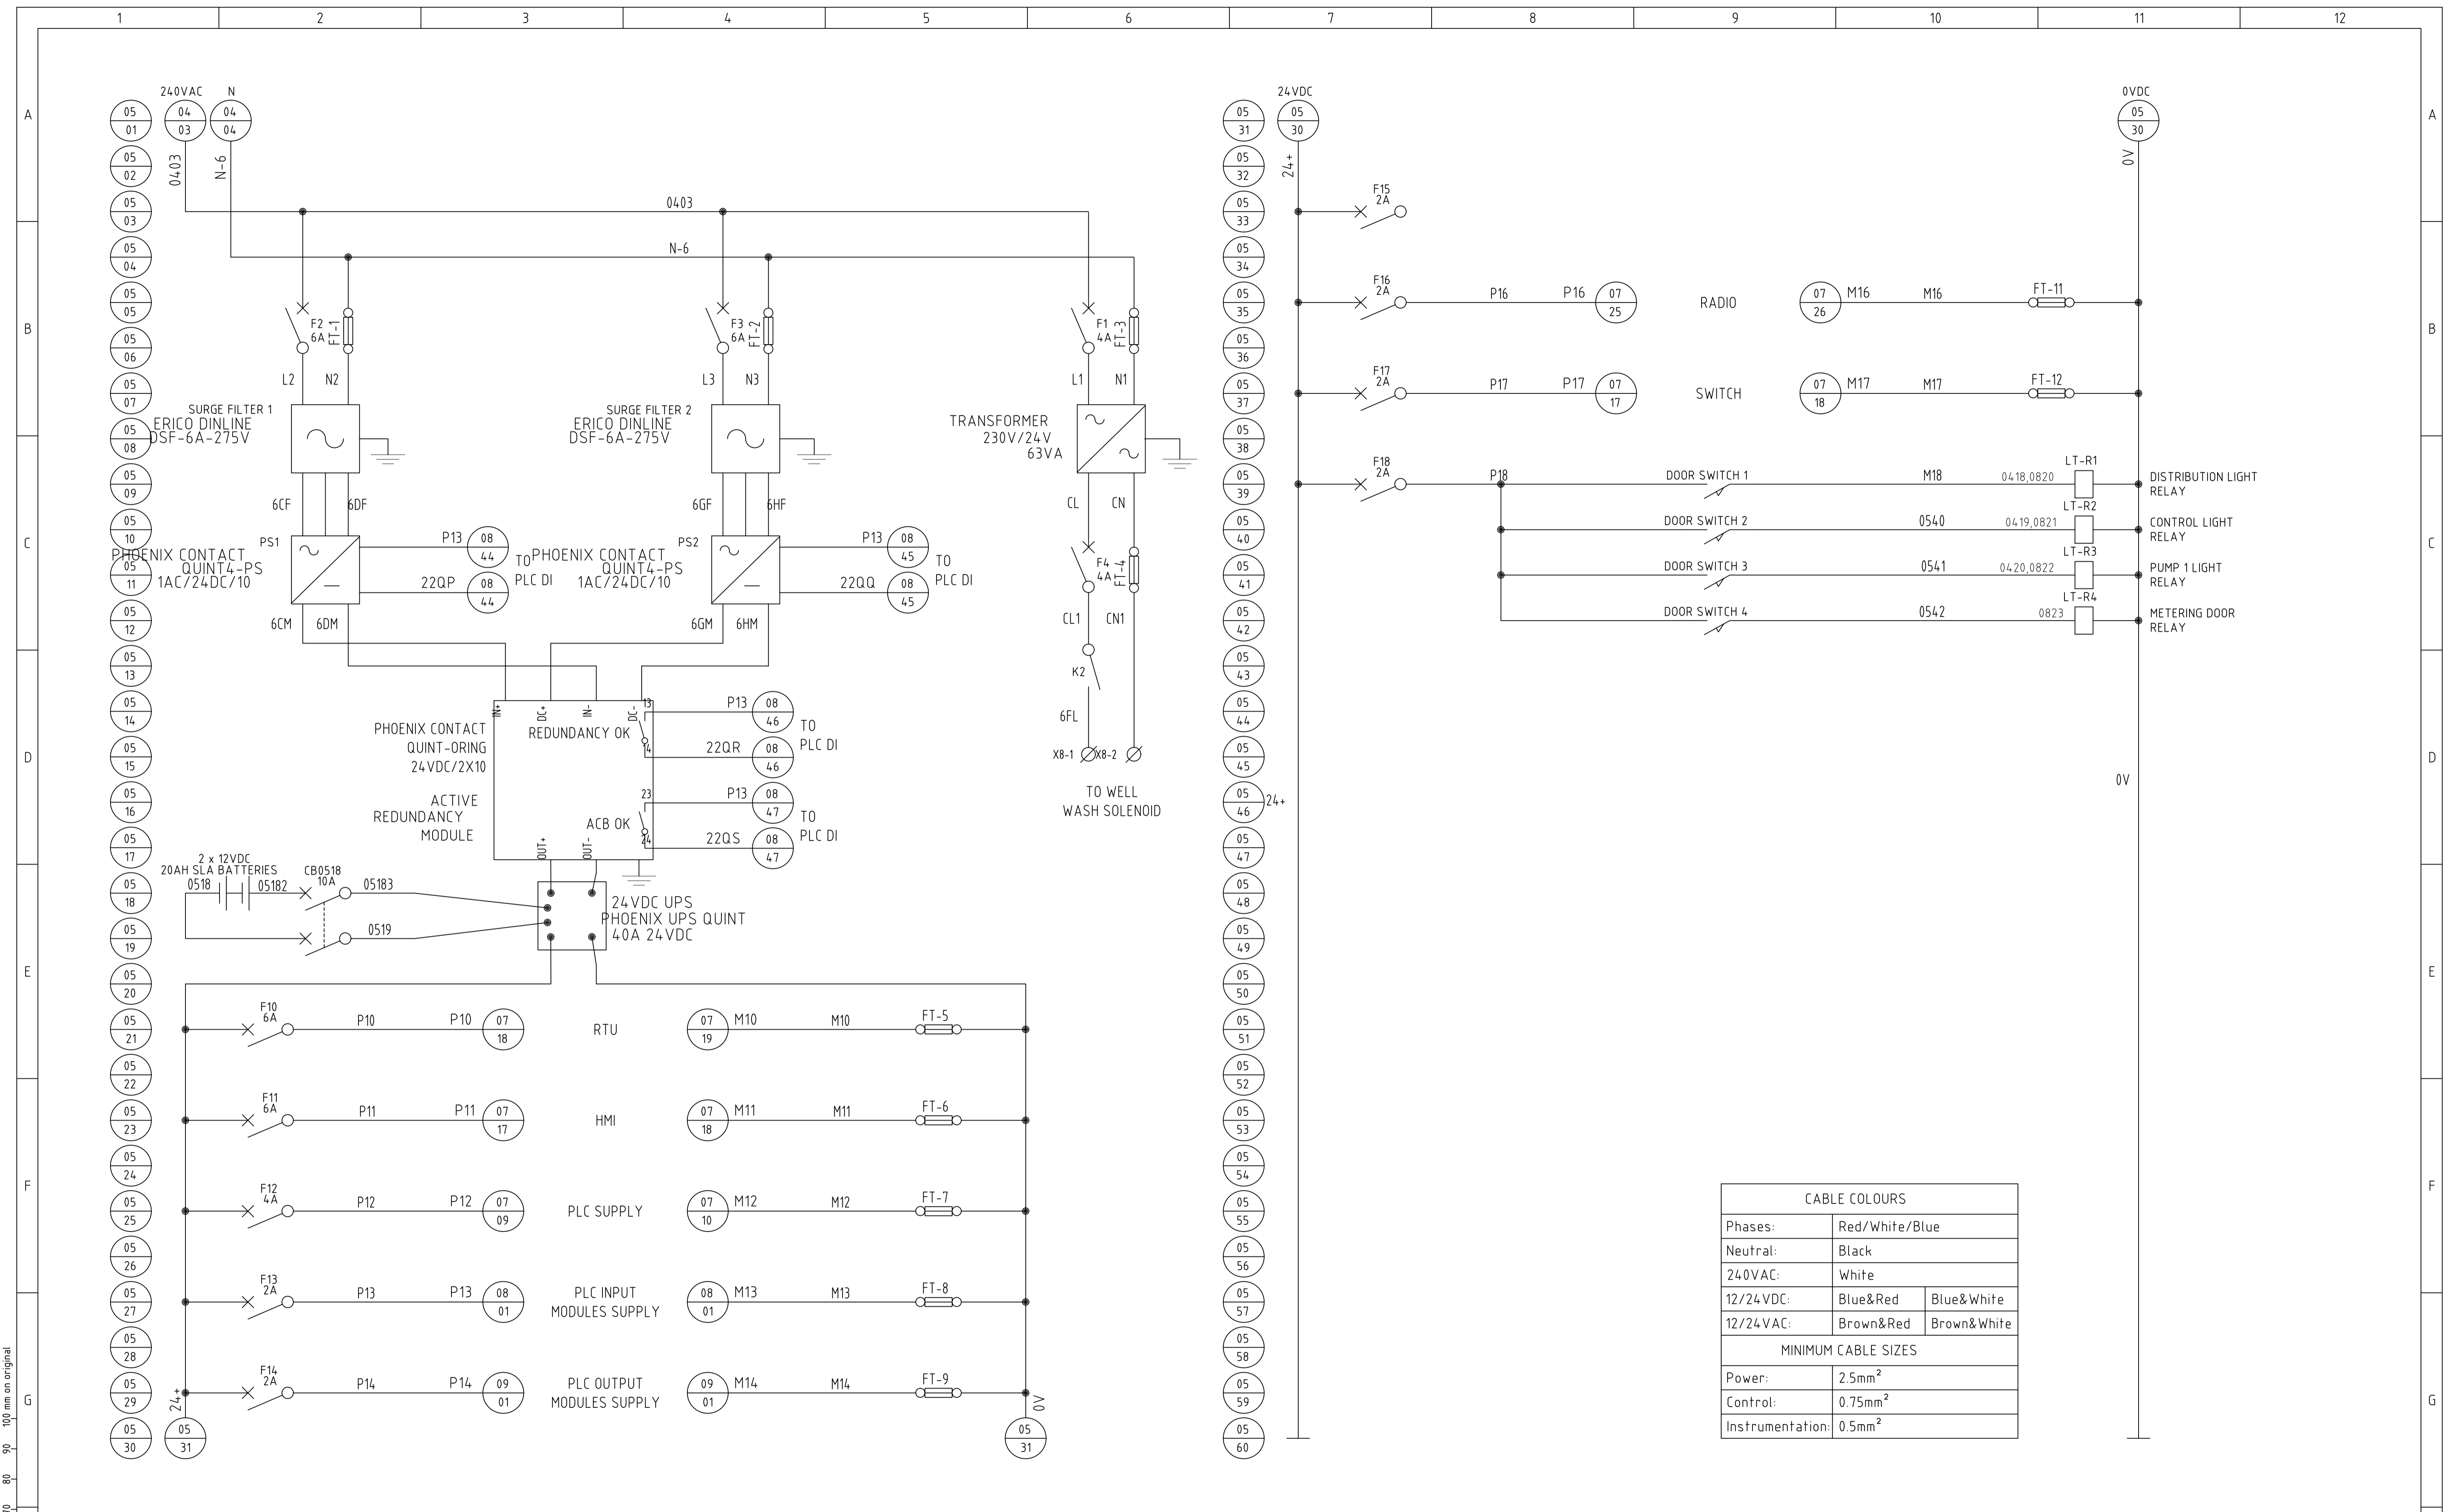

CABLE COLOURS	
Phases:	Red/White/Blue
Neutral:	Black
240VAC:	White
12/24VDC:	Blue&Red Blue&White
12/24VAC:	Brown&Red Brown&White
MINIMUM CABLE SIZES	
Power:	2.5mm ²
Control:	0.75mm ²
Instrumentation:	0.5mm ²


				SURVEYED: DATE: COMPANY: DESIGNED: CE 15/02/24 SW DRAWN: GJ 04/06/24 SW CHECKED: AR 04/06/24 SW APPROVED: DATE: COMPANY:		TITLE: SMALL SPS SCA PANEL (TYPICAL) ELECTRICAL SCHEMATIC CONTROLS	
City Administrative Centre PO Box 42, Nowra, NSW 2541 Ph 02 4429 3111 www.shoalwater.nsw.gov.au		TRIM REFERENCE No 47662E		INDEX No 23557		DRAWING No 05	
CONSULTANT DETAILS: SIZE: A1 SCALE FACTOR: N.T.S. CO-ORDINATE SYSTEM: MGA 2020 Zone 56 HEIGHT DATUM: AHD		SHEET 05		REV No 0			

No.	REVISION DETAILS	DWN	DATE
0	ISSUED FOR REVIEW	GJ	04/06/24

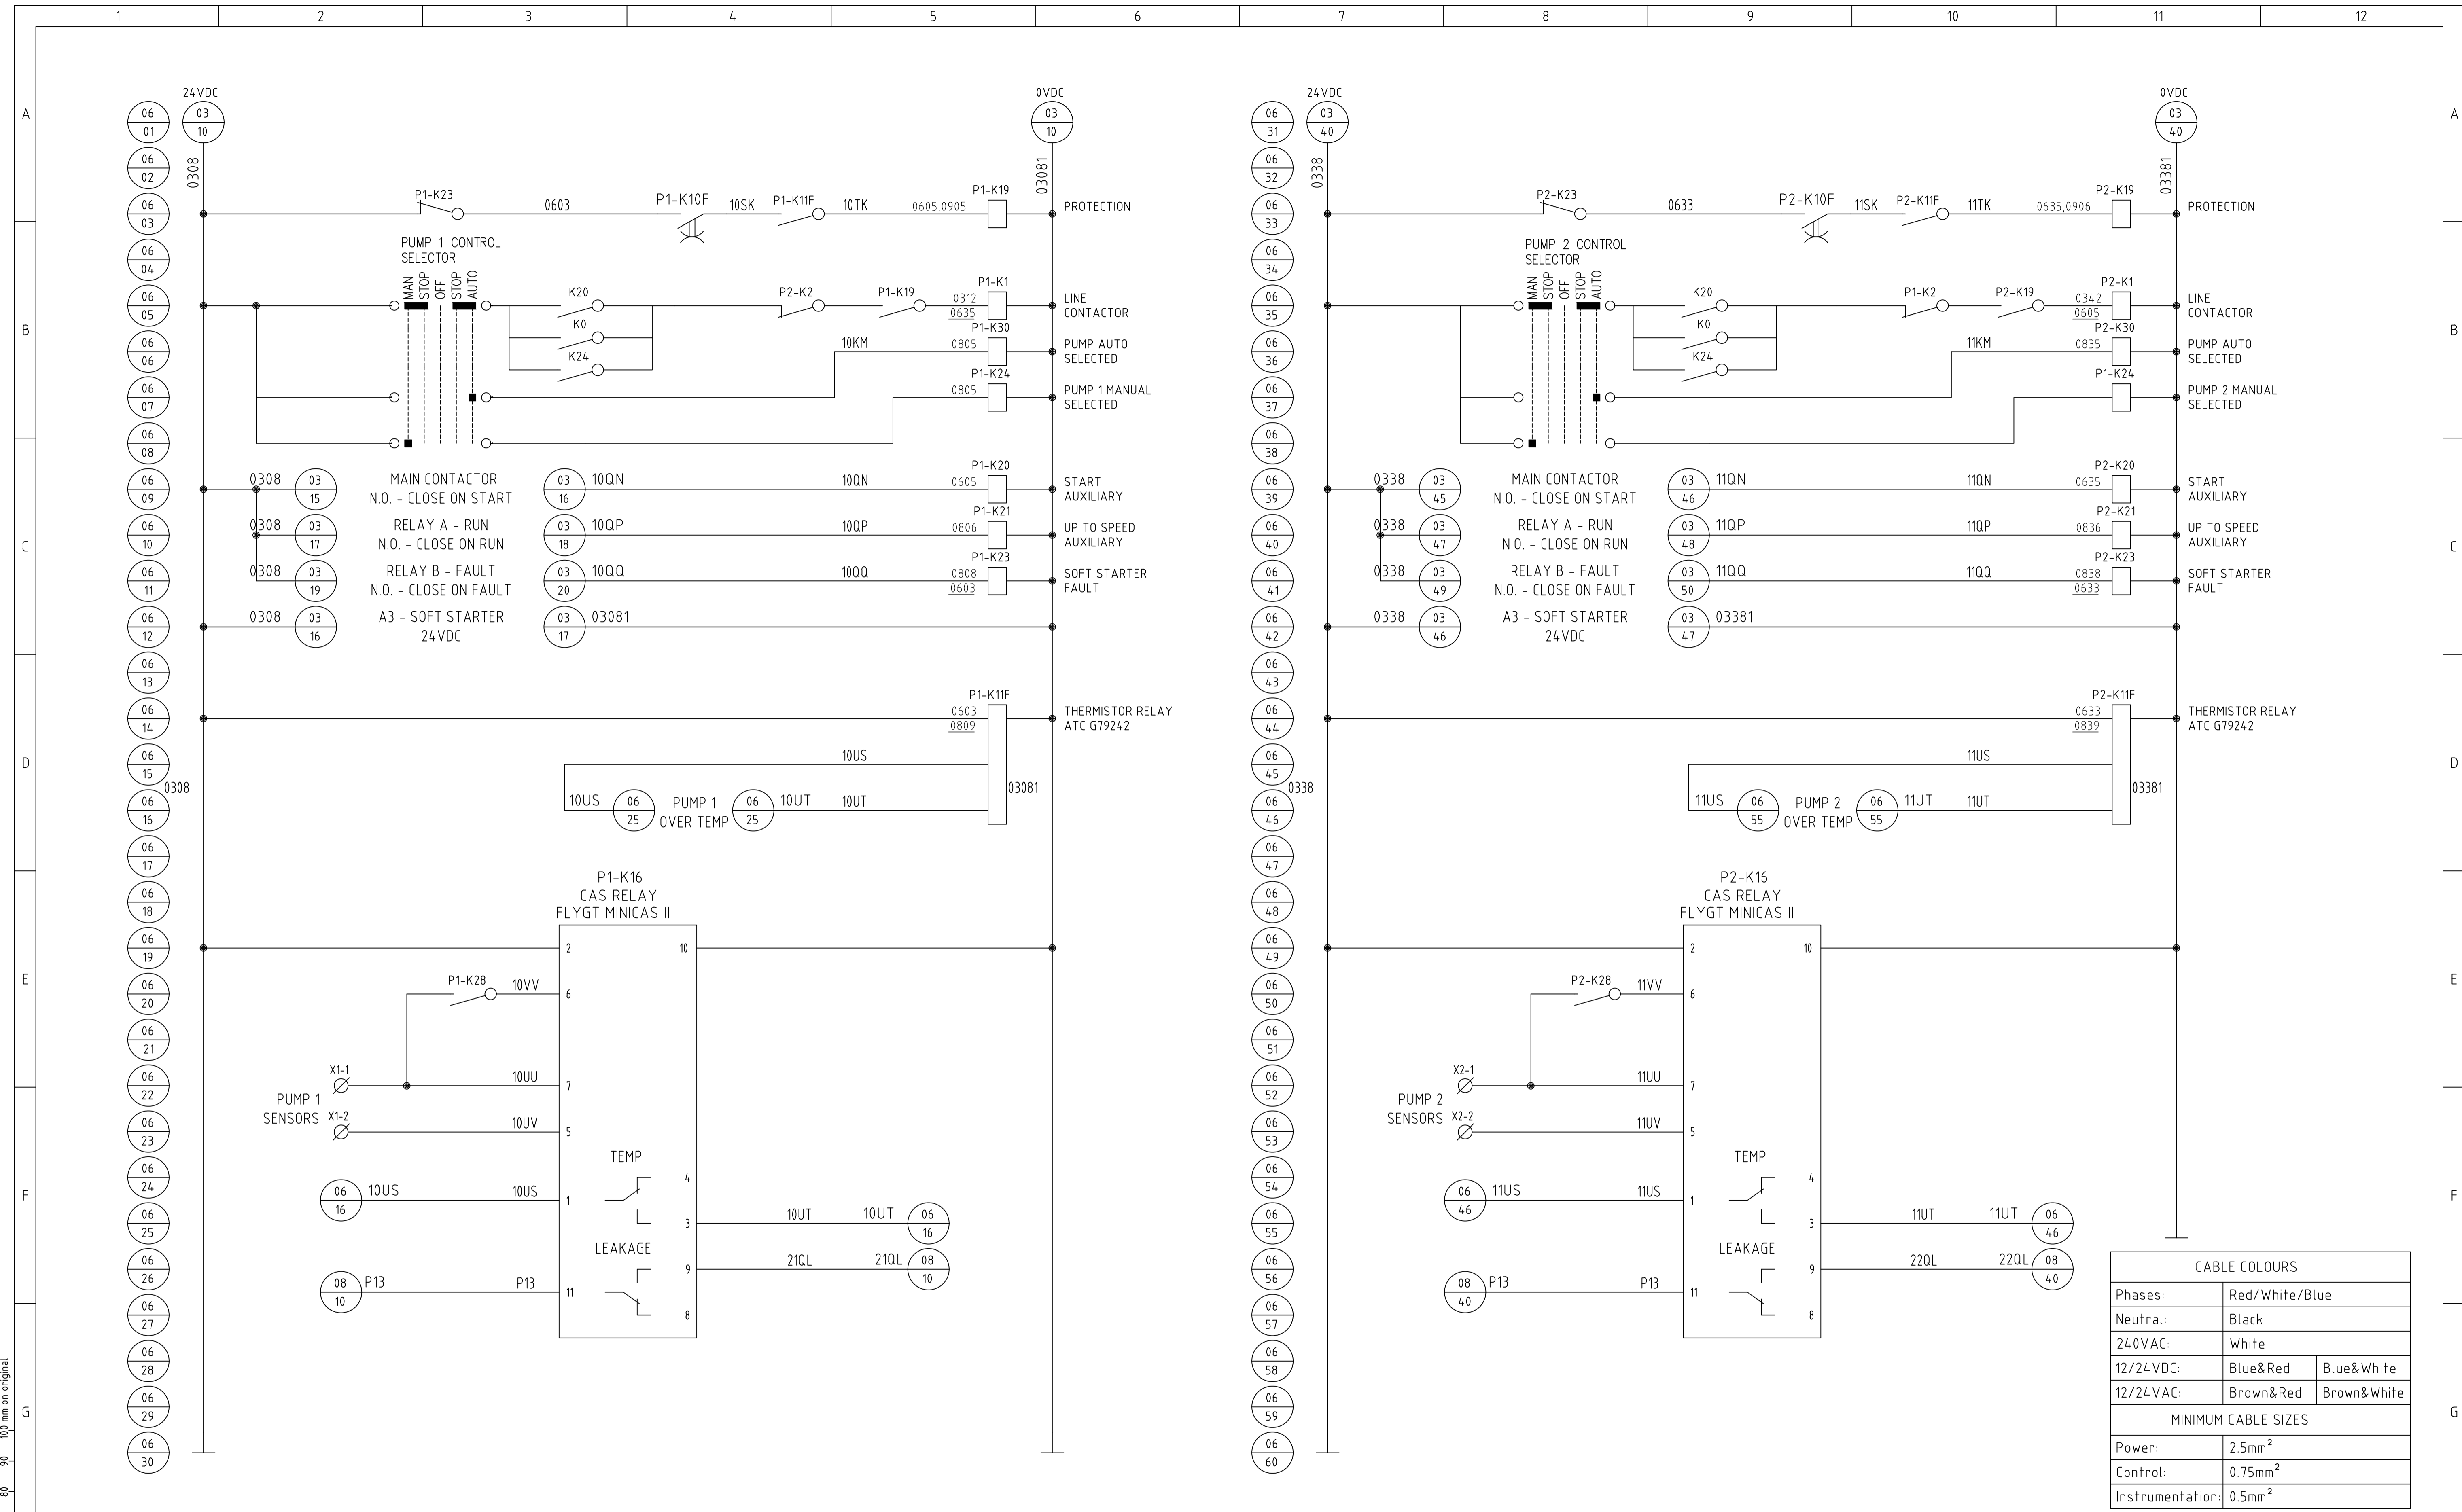


CABLE COLOURS			
Phases:	Red/White/Blue		
Neutral:	Black		
240VAC:	White		
12/24VDC:	Blue&Red	Blue&White	
12/24VAC:	Brown&Red	Brown&White	
MINIMUM CABLE SIZES			
Power:	2.5mm ²		
Control:	0.75mm ²		
Instrumentation:	0.5mm ²		

CONSULTANT DETAILS:				<p>City Administrative Centre PO Box 42, Nowra, NSW 2541 Ph 02 4429 3111 www.shoalwater.nsw.gov.au</p>		SURVEYED: _____ DATE: _____ COMPANY: _____		TITLE: SMALL SPS SCA PANEL (TYPICAL) ELECTRICAL SCHEMATIC PUMP CONTROLS			
DESIGNED: CE DATE: 15/02/24 COMPANY: SW						DRAWN: GJ DATE: 04/06/24 COMPANY: SW		CHECKED: AR DATE: 04/06/24 COMPANY: SW		APPROVED: _____ DATE: _____ COMPANY: _____	
0 ISSUED FOR REVIEW				GJ 04/06/24		SIZE: A1 SCALE FACTOR: N.T.S.		CO-ORDINATE SYSTEM: MGA 2020 Zone 56		DRAWING No: 06	
REVISION DETAILS				DWN DATE		HEIGHT DATUM: AHD		INDEX No: 23557		SHEET 06 REV No. 0	

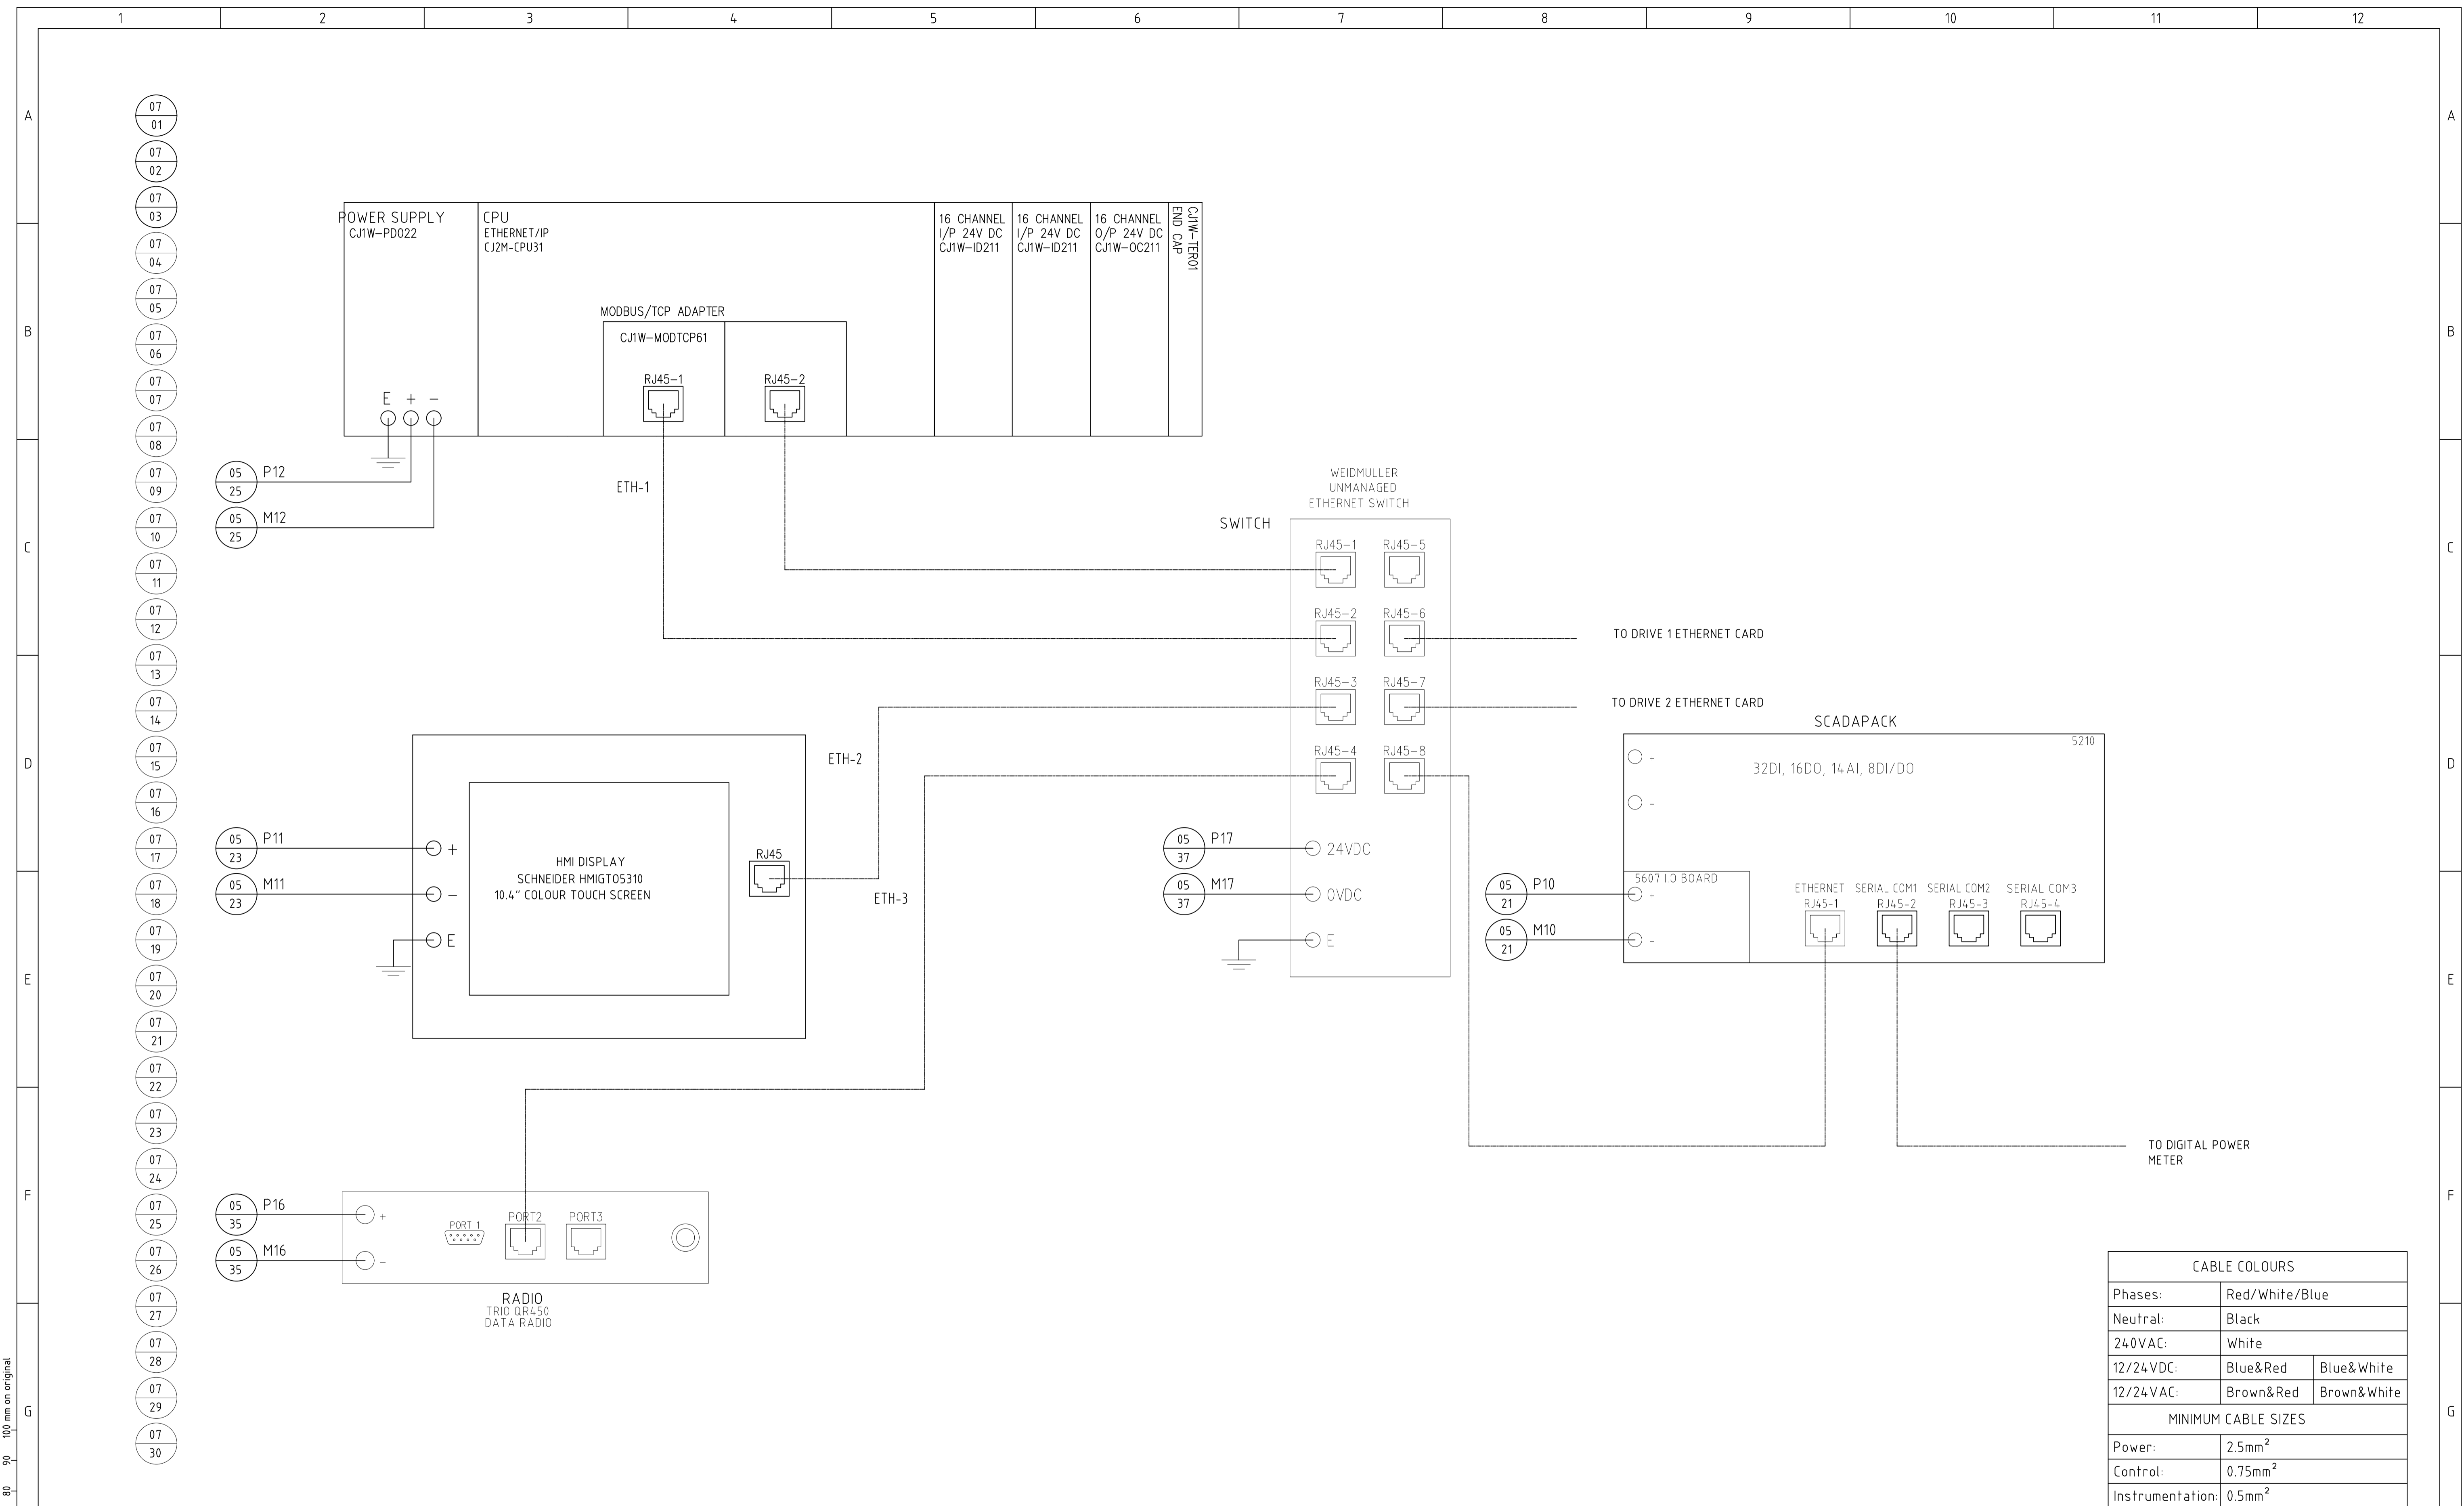


CABLE COLOURS	
Phases:	Red/White/Blue
Neutral:	Black
240VAC:	White
12/24VDC:	Blue&Red Blue&White
12/24VAC:	Brown&Red Brown&White
MINIMUM CABLE SIZES	
Power:	2.5mm ²
Control:	0.75mm ²
Instrumentation:	0.5mm ²

CONSULTANT DETAILS:				 City Administrative Centre PO Box 42, Nowra, NSW 2541 Ph 02 4429 3111 www.shoalwater.nsw.gov.au		SURVEYED: DATE: COMPANY:		TITLE: SMALL SPS SCA PANEL (TYPICAL) ELECTRICAL SCHEMATIC PLC HMI OVERVIEW			
DESIGNED: CE DATE: 15/02/24 COMPANY: SW						DRAWN: GJ DATE: 04/06/24 COMPANY: SW					
CHECKED: AR DATE: 04/06/24 COMPANY: SW				APPROVED: DATE: COMPANY:		TRIM REFERENCE No: 47662E		INDEX No: 23557		DRAWING No: 07	
REVISION DETAILS				SIZE: A1 SCALE FACTOR: N.T.S.		CO-ORDINATE SYSTEM: MGA 2020 Zone 56		SHEET: 07		REV No: 0	
0 ISSUED FOR REVIEW GJ 04/06/24				HEIGHT DATUM: AHD							

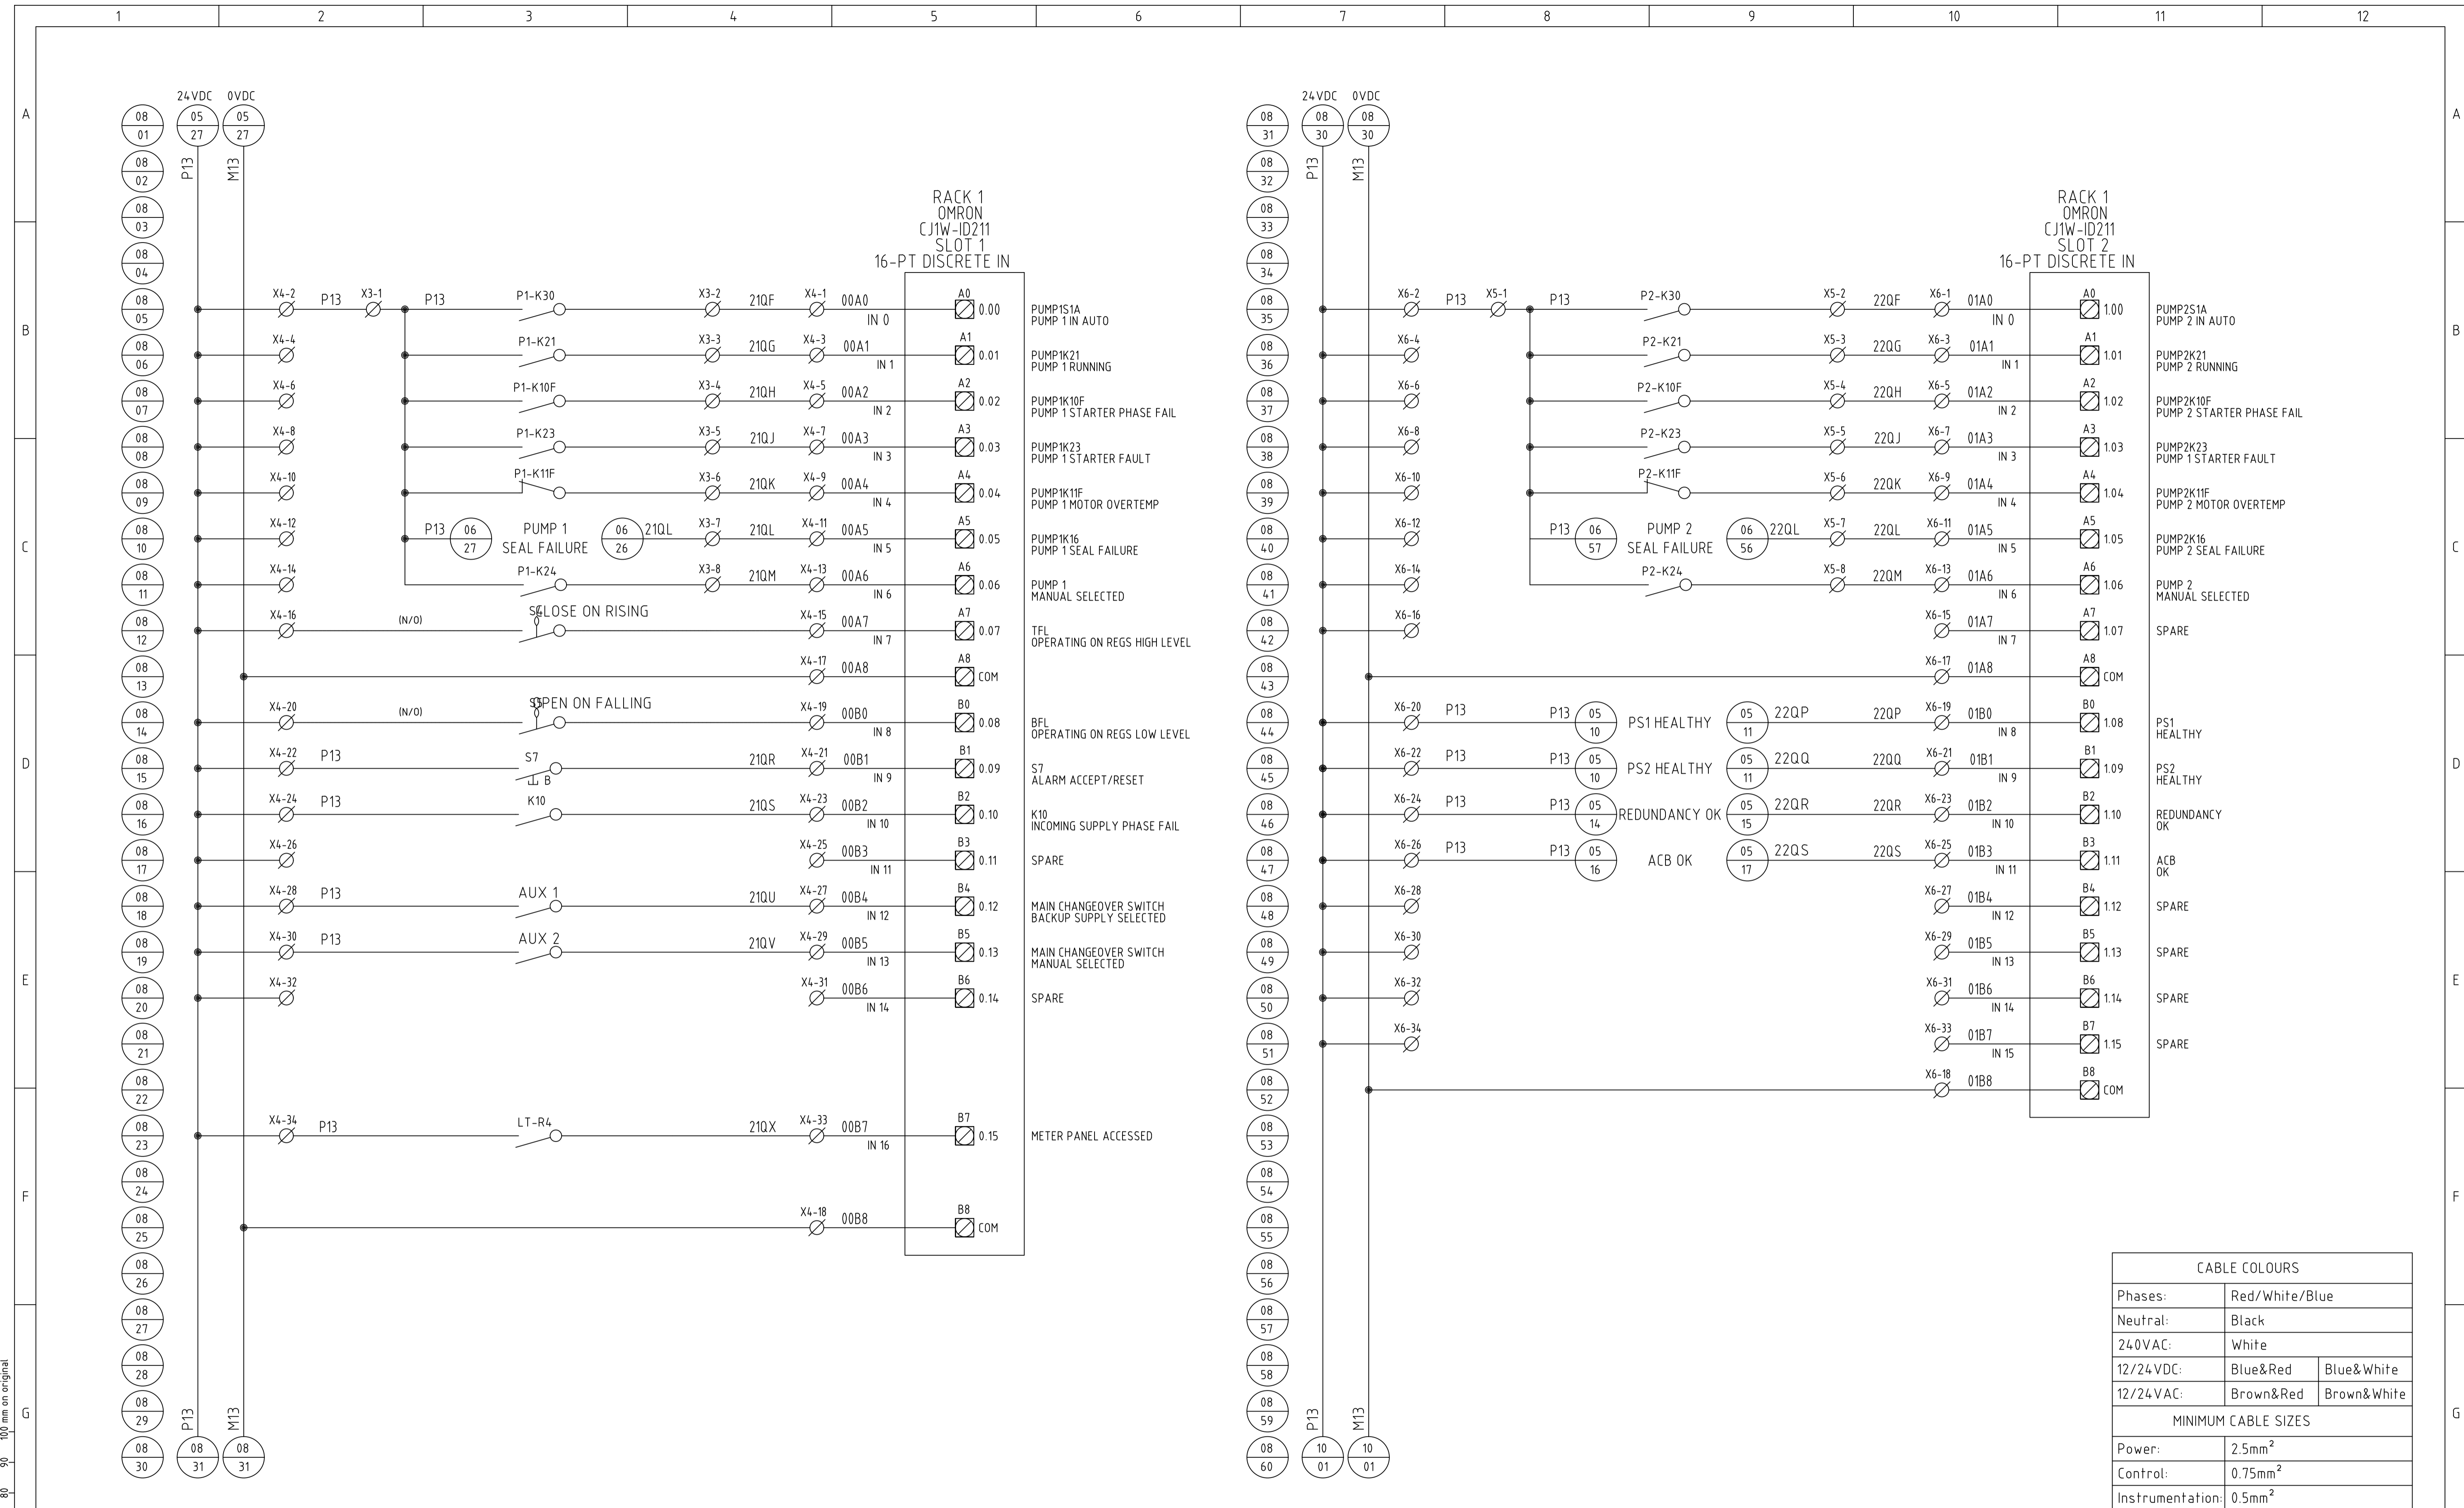


CABLE COLOURS		
Phases:	Red/White/Blue	
Neutral:	Black	
240VAC:	White	
12/24VDC:	Blue&Red	Blue&White
12/24VAC:	Brown&Red	Brown&White
MINIMUM CABLE SIZES		
Power:	2.5mm ²	
Control:	0.75mm ²	
Instrumentation:	0.5mm ²	

CONSULTANT DETAILS:						SURVEYED: DATE: COMPANY:		TITLE: SMALL SPS SCA PANEL (TYPICAL) ELECTRICAL SCHEMATIC PLC DIGITAL INPUT										
				City Administrative Centre PO Box 42, Nowra, NSW 2541 Ph 02 4429 3111 www.shoalwater.nsw.gov.au		DESIGNED: CE DATE: 15/02/24 COMPANY: SW												
						DRAWN: GJ DATE: 04/06/24 COMPANY: SW												
						CHECKED: AR DATE: 04/06/24 COMPANY: SW												
						APPROVED: DATE: COMPANY:		TRIM REFERENCE No: 47662E		INDEX No: 23557		DRAWING No: 08		SHEET: 08		REV No: 0		
0 ISSUED FOR REVIEW		GJ 04/06/24		SIZE: A1 SCALE FACTOR: N.T.S.		CO-ORDINATE SYSTEM: MGA 2020 Zone 56		HEIGHT DATUM: AHD										
REVISION DETAILS																		
No.	1	2	3	4	5	6	7	8	9	10	11	12						

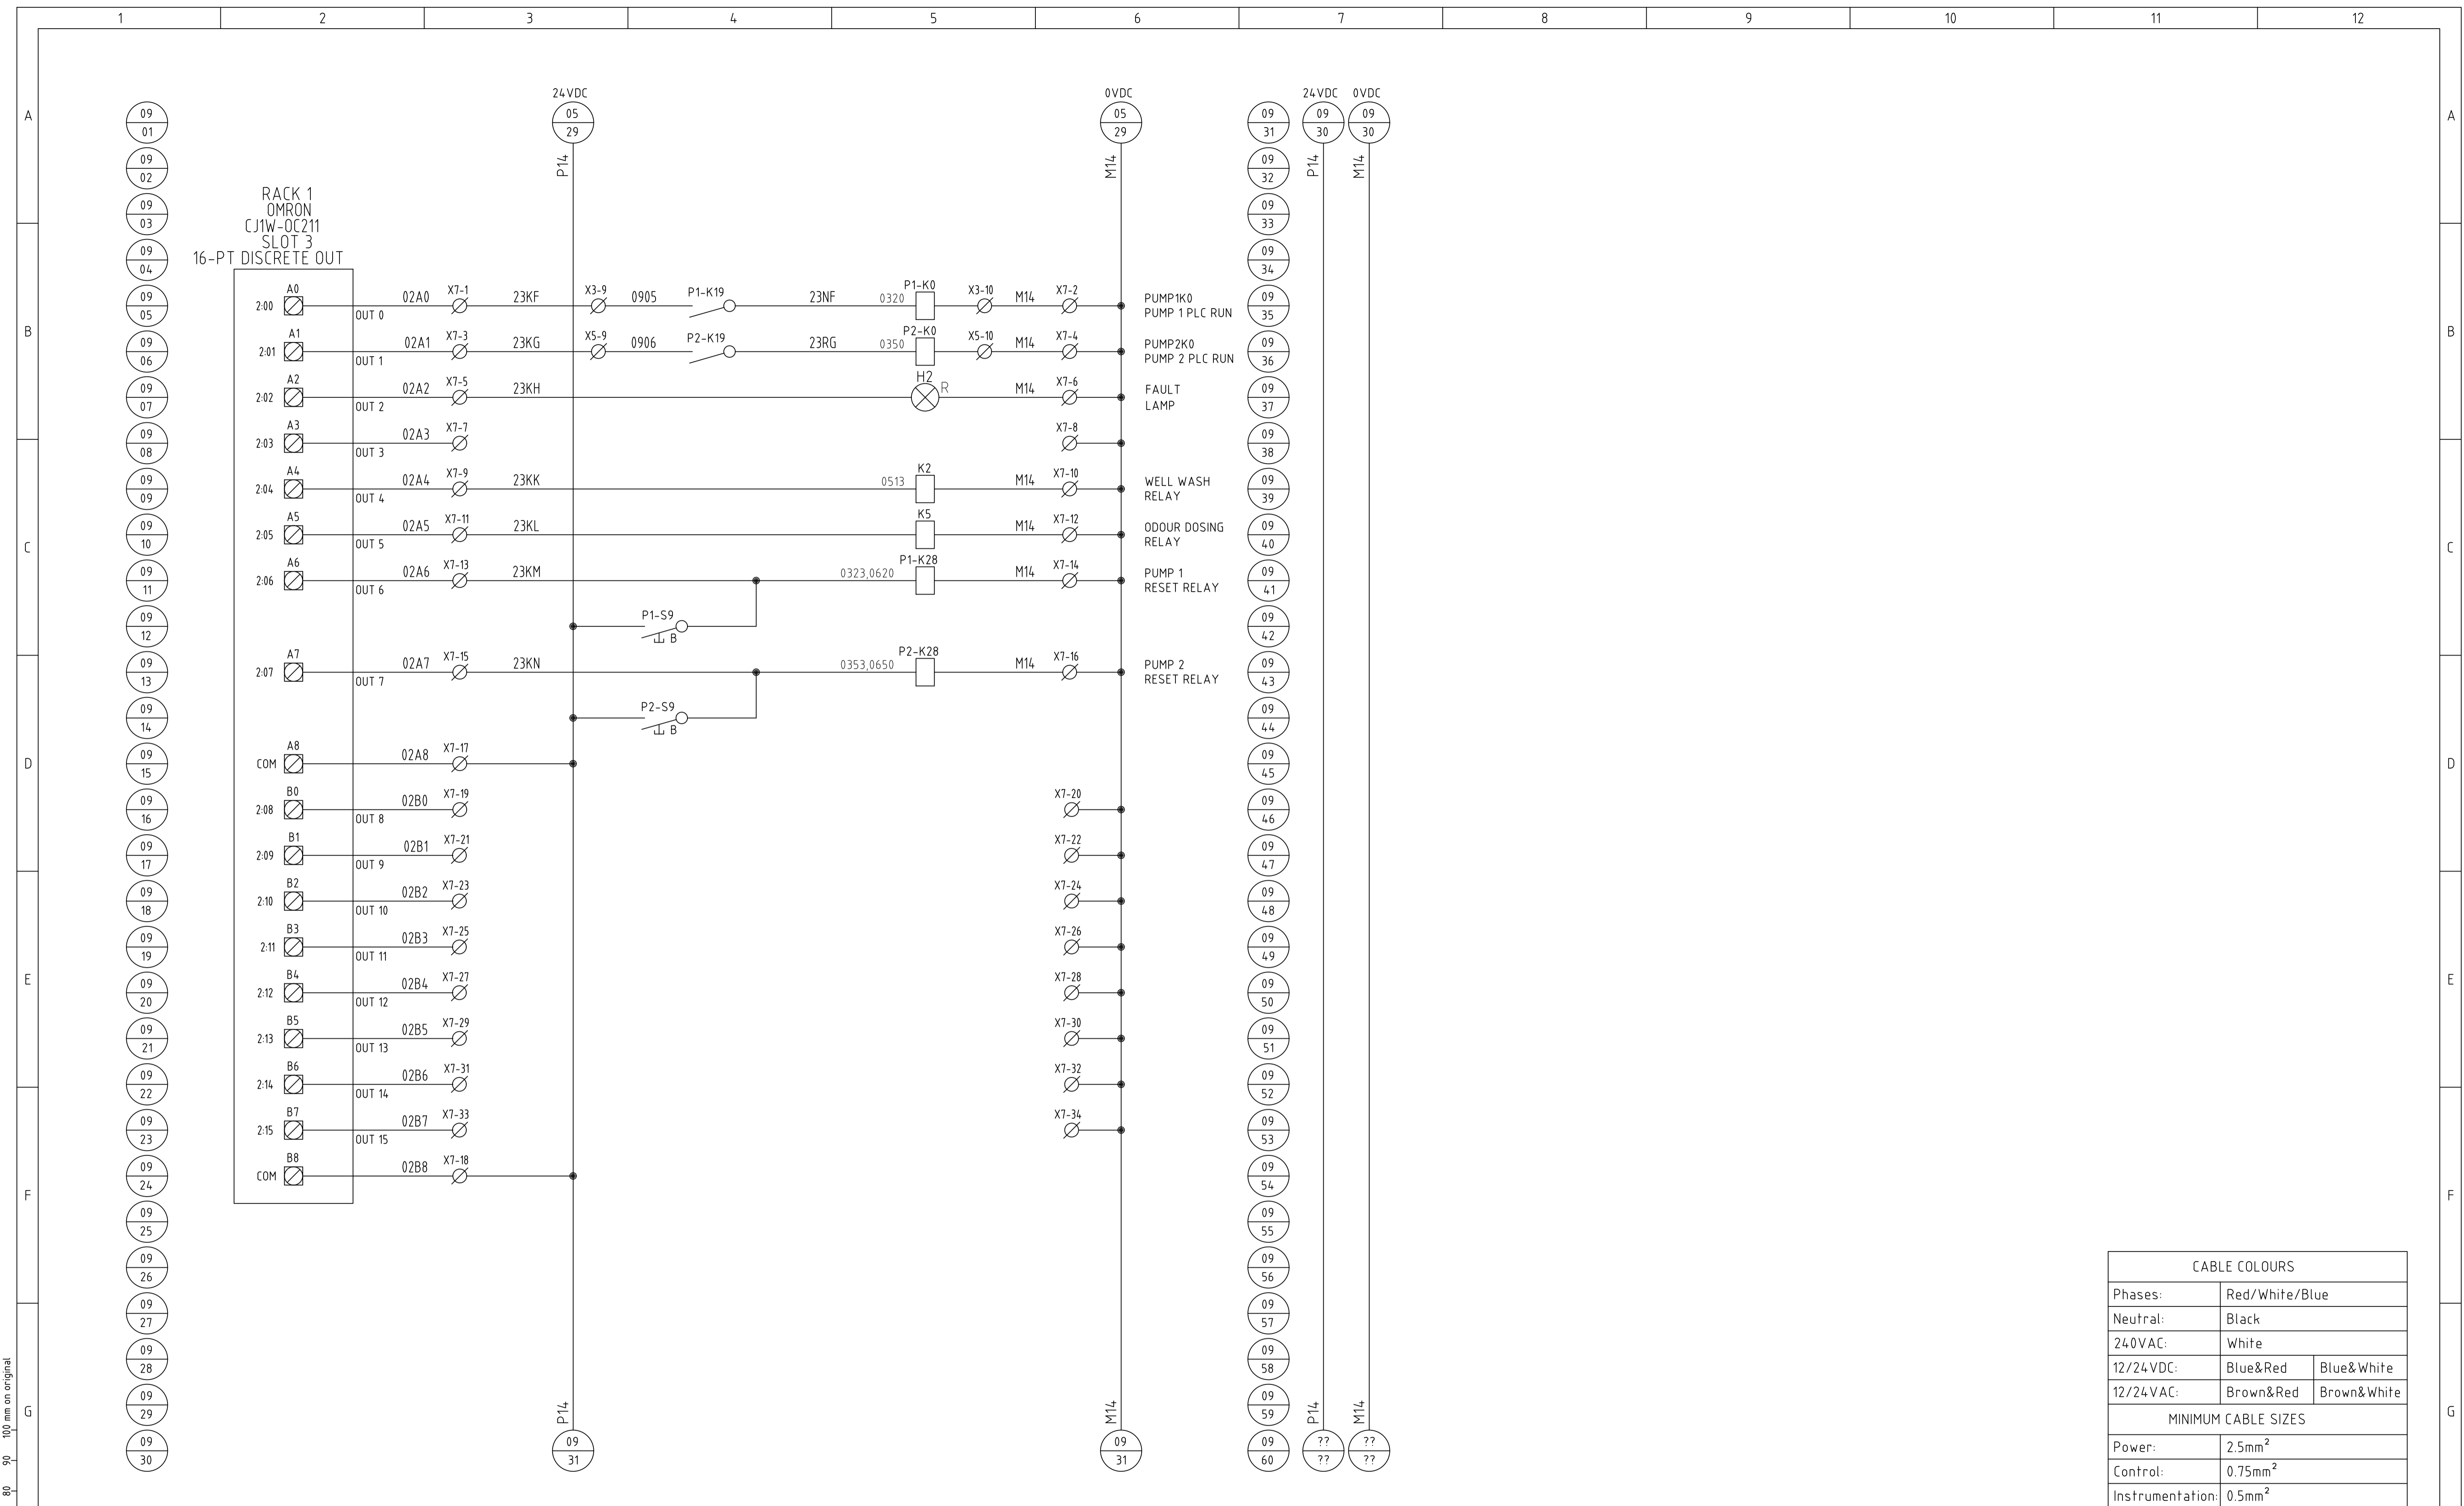

CABLE COLOURS		
Phases:	Red/White/Blue	
Neutral:	Black	
240VAC:	White	
12/24VDC:	Blue&Red	Blue&White
12/24VAC:	Brown&Red	Brown&White
MINIMUM CABLE SIZES		
Power:	2.5mm ²	
Control:	0.75mm ²	
Instrumentation:	0.5mm ²	


				CONSULTANT DETAILS:		SURVEYED:		DATE:	COMPANY:	TITLE:					
						DESIGNED:		DATE:	COMPANY:	SMALL SPS SCA PANEL (TYPICAL)					
						DRAWN:		DATE:	COMPANY:	ELECTRICAL SCHEMATIC					
						CHECKED:		DATE:	COMPANY:	PLC DIGITAL OUTPUT					
						APPROVED:		DATE:	COMPANY:	TRIM REFERENCE No					
0 ISSUED FOR REVIEW				GJ	04/06/24	SIZE:	SCALE FACTOR:	CO-ORDINATE SYSTEM:	MGA 2020 Zone 56	DRAWING No		SHEET	REV No		
No.	REVISION DETAILS			DWN	DATE	A1	N.T.S.	HEIGHT DATUM:	AHD	47662E		23557	09	09	0
1															
2															
3															
4															
5															
6															
7															
8															
9															
10															
11															
12															

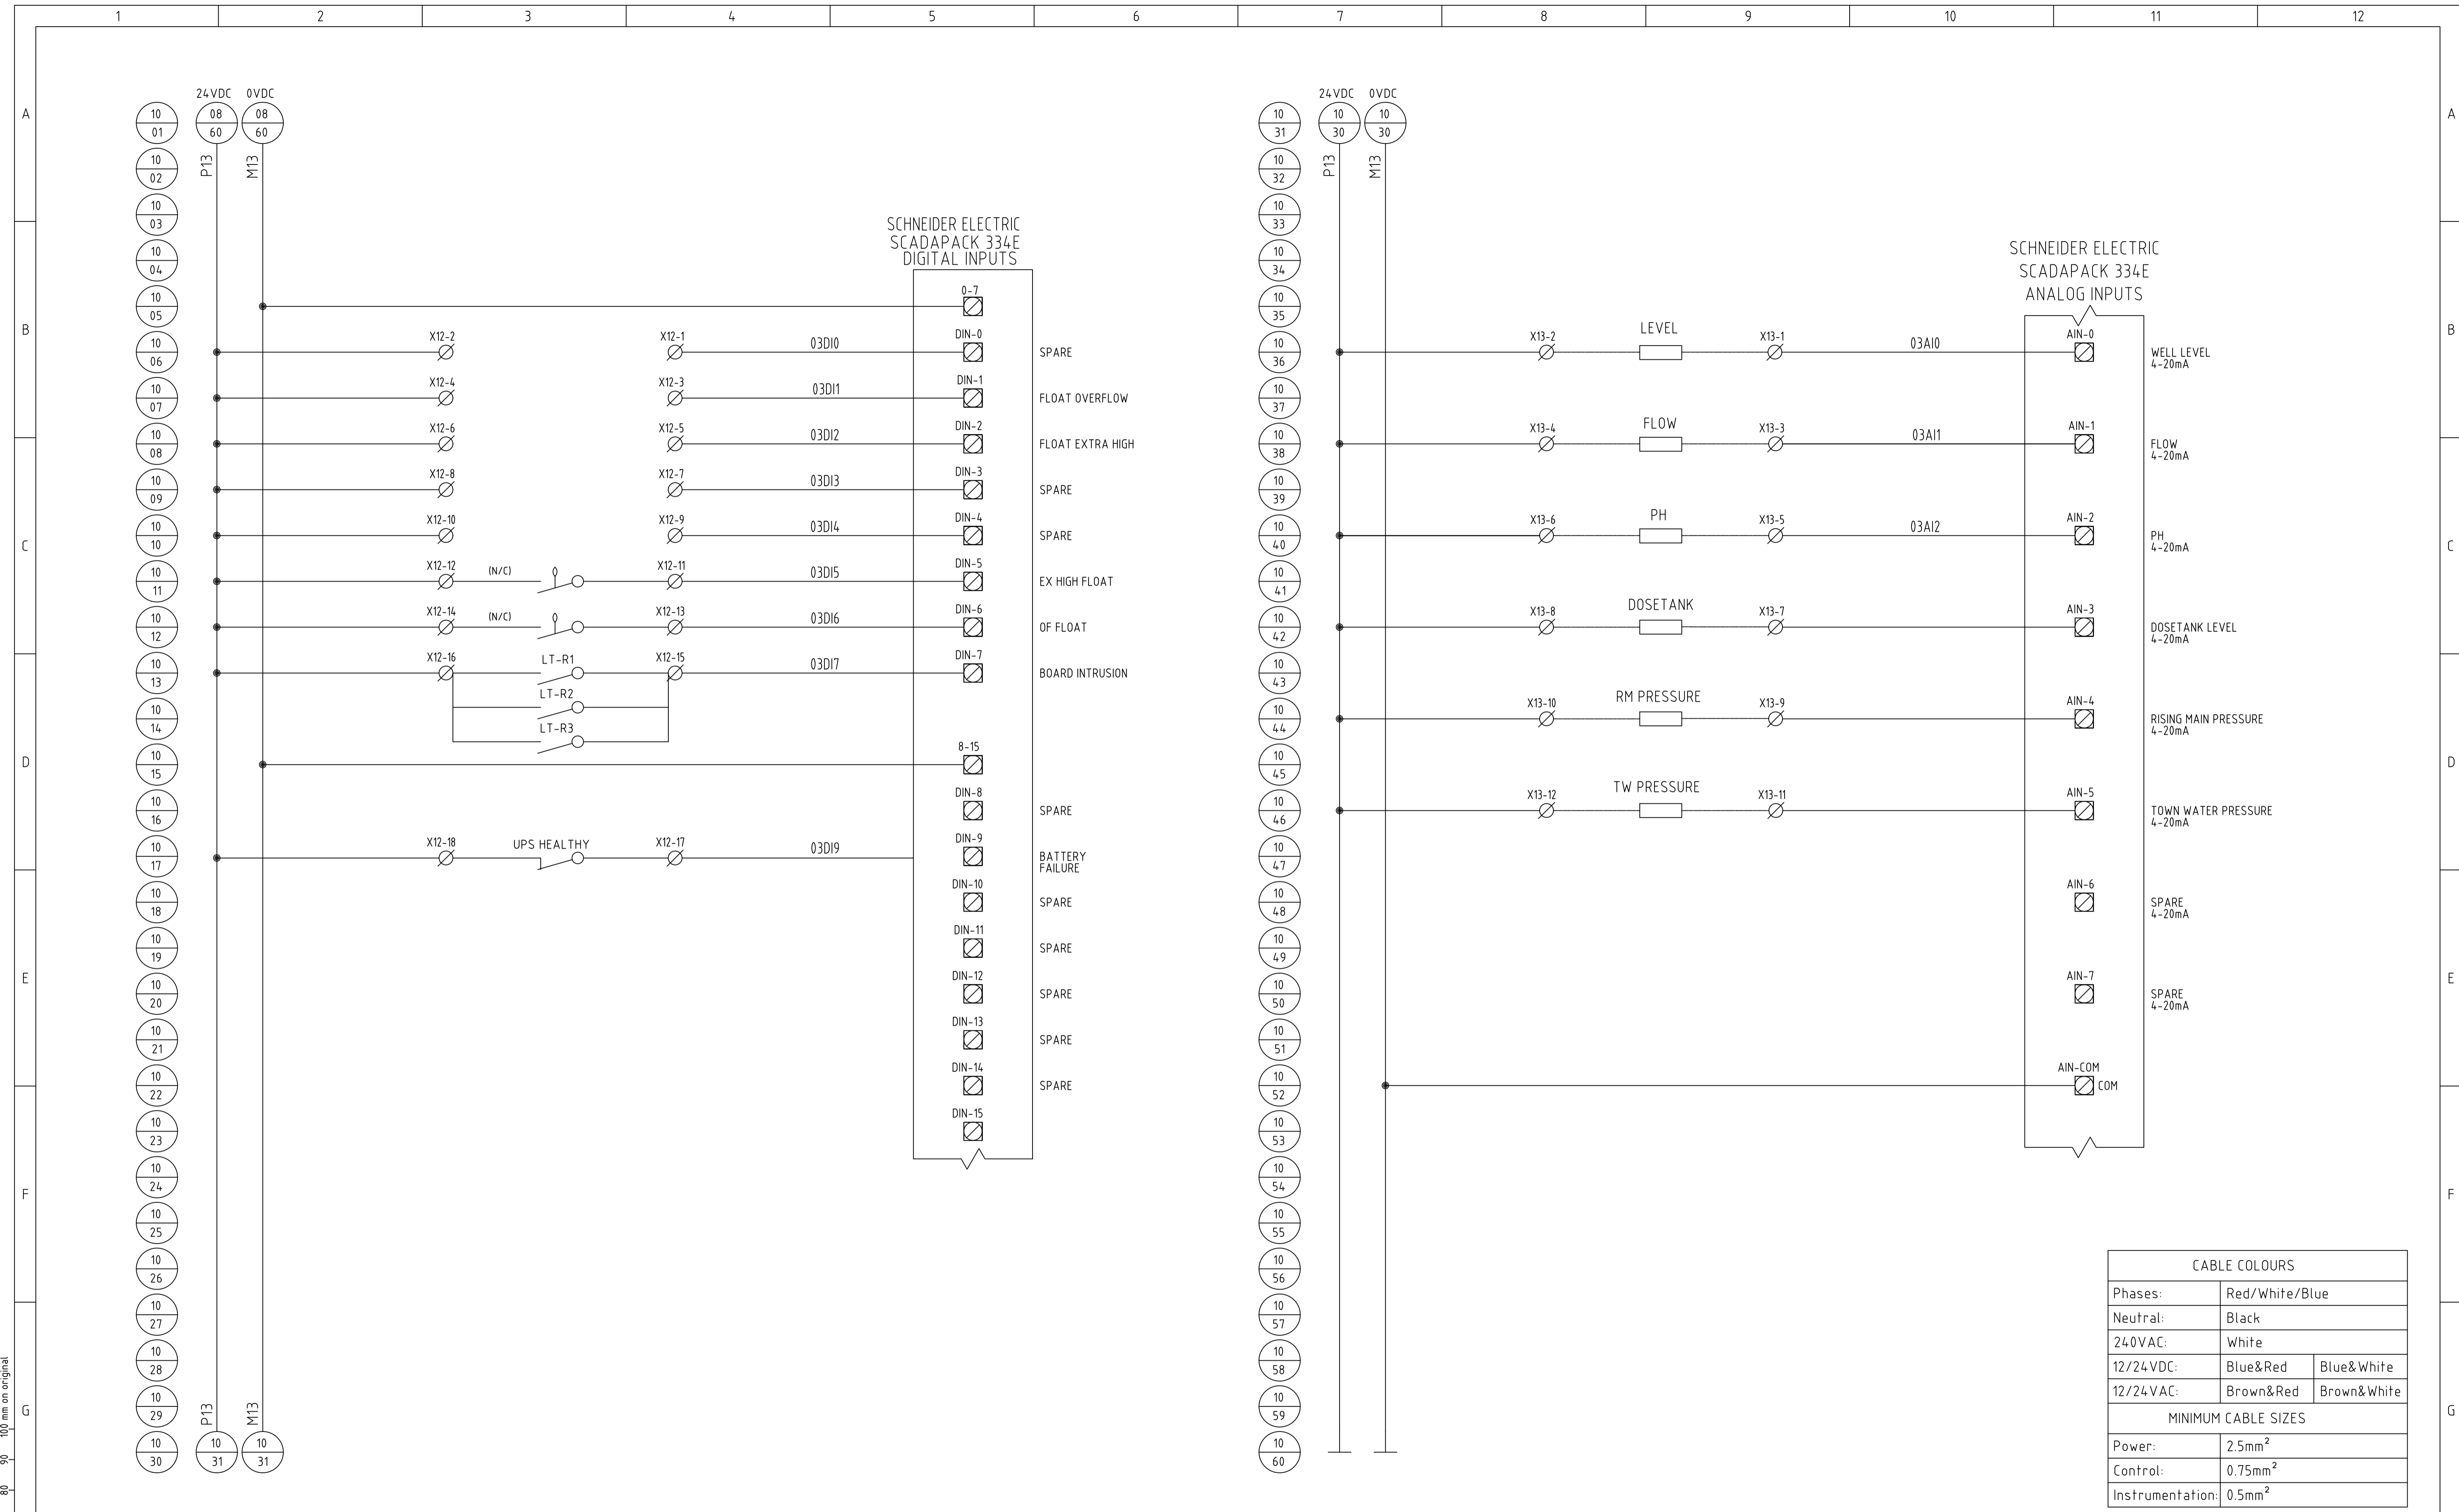


CABLE COLOURS		
Phases:	Red/White/Blue	
Neutral:	Black	
240VAC:	White	
12/24VDC:	Blue&Red	Blue&White
12/24VAC:	Brown&Red	Brown&White
MINIMUM CABLE SIZES		
Power:	2.5mm ²	
Control:	0.75mm ²	
Instrumentation:	0.5mm ²	

CONSULTANT DETAILS:				 City Administrative Centre PO Box 42, Nowra, NSW 2541 Ph 02 4429 3111 www.shoalwater.nsw.gov.au		SURVEYED: _____ DATE: _____ COMPANY: _____		TITLE: SMALL SPS SCA PANEL (TYPICAL) ELECTRICAL SCHEMATIC RTU DIGITAL INPUT / ANALOG INPUT			
DESIGNED: CE DATE: 15/02/24 COMPANY: SW						DRAWN: GJ DATE: 04/06/24 COMPANY: SW		CHECKED: AR DATE: 04/06/24 COMPANY: SW		APPROVED: _____ DATE: _____ COMPANY: _____	
0 ISSUED FOR REVIEW		GJ 04/06/24		SIZE: A1 SCALE FACTOR: N.T.S.		CO-ORDINATE SYSTEM: MGA 2020 Zone 56		DRAWING No: 10		SHEET 10	
REVISION DETAILS		DWN DATE		HEIGHT DATUM: AHD		INDEX No: 23557		REV No: 0			


COMMON AUTO CONTROL

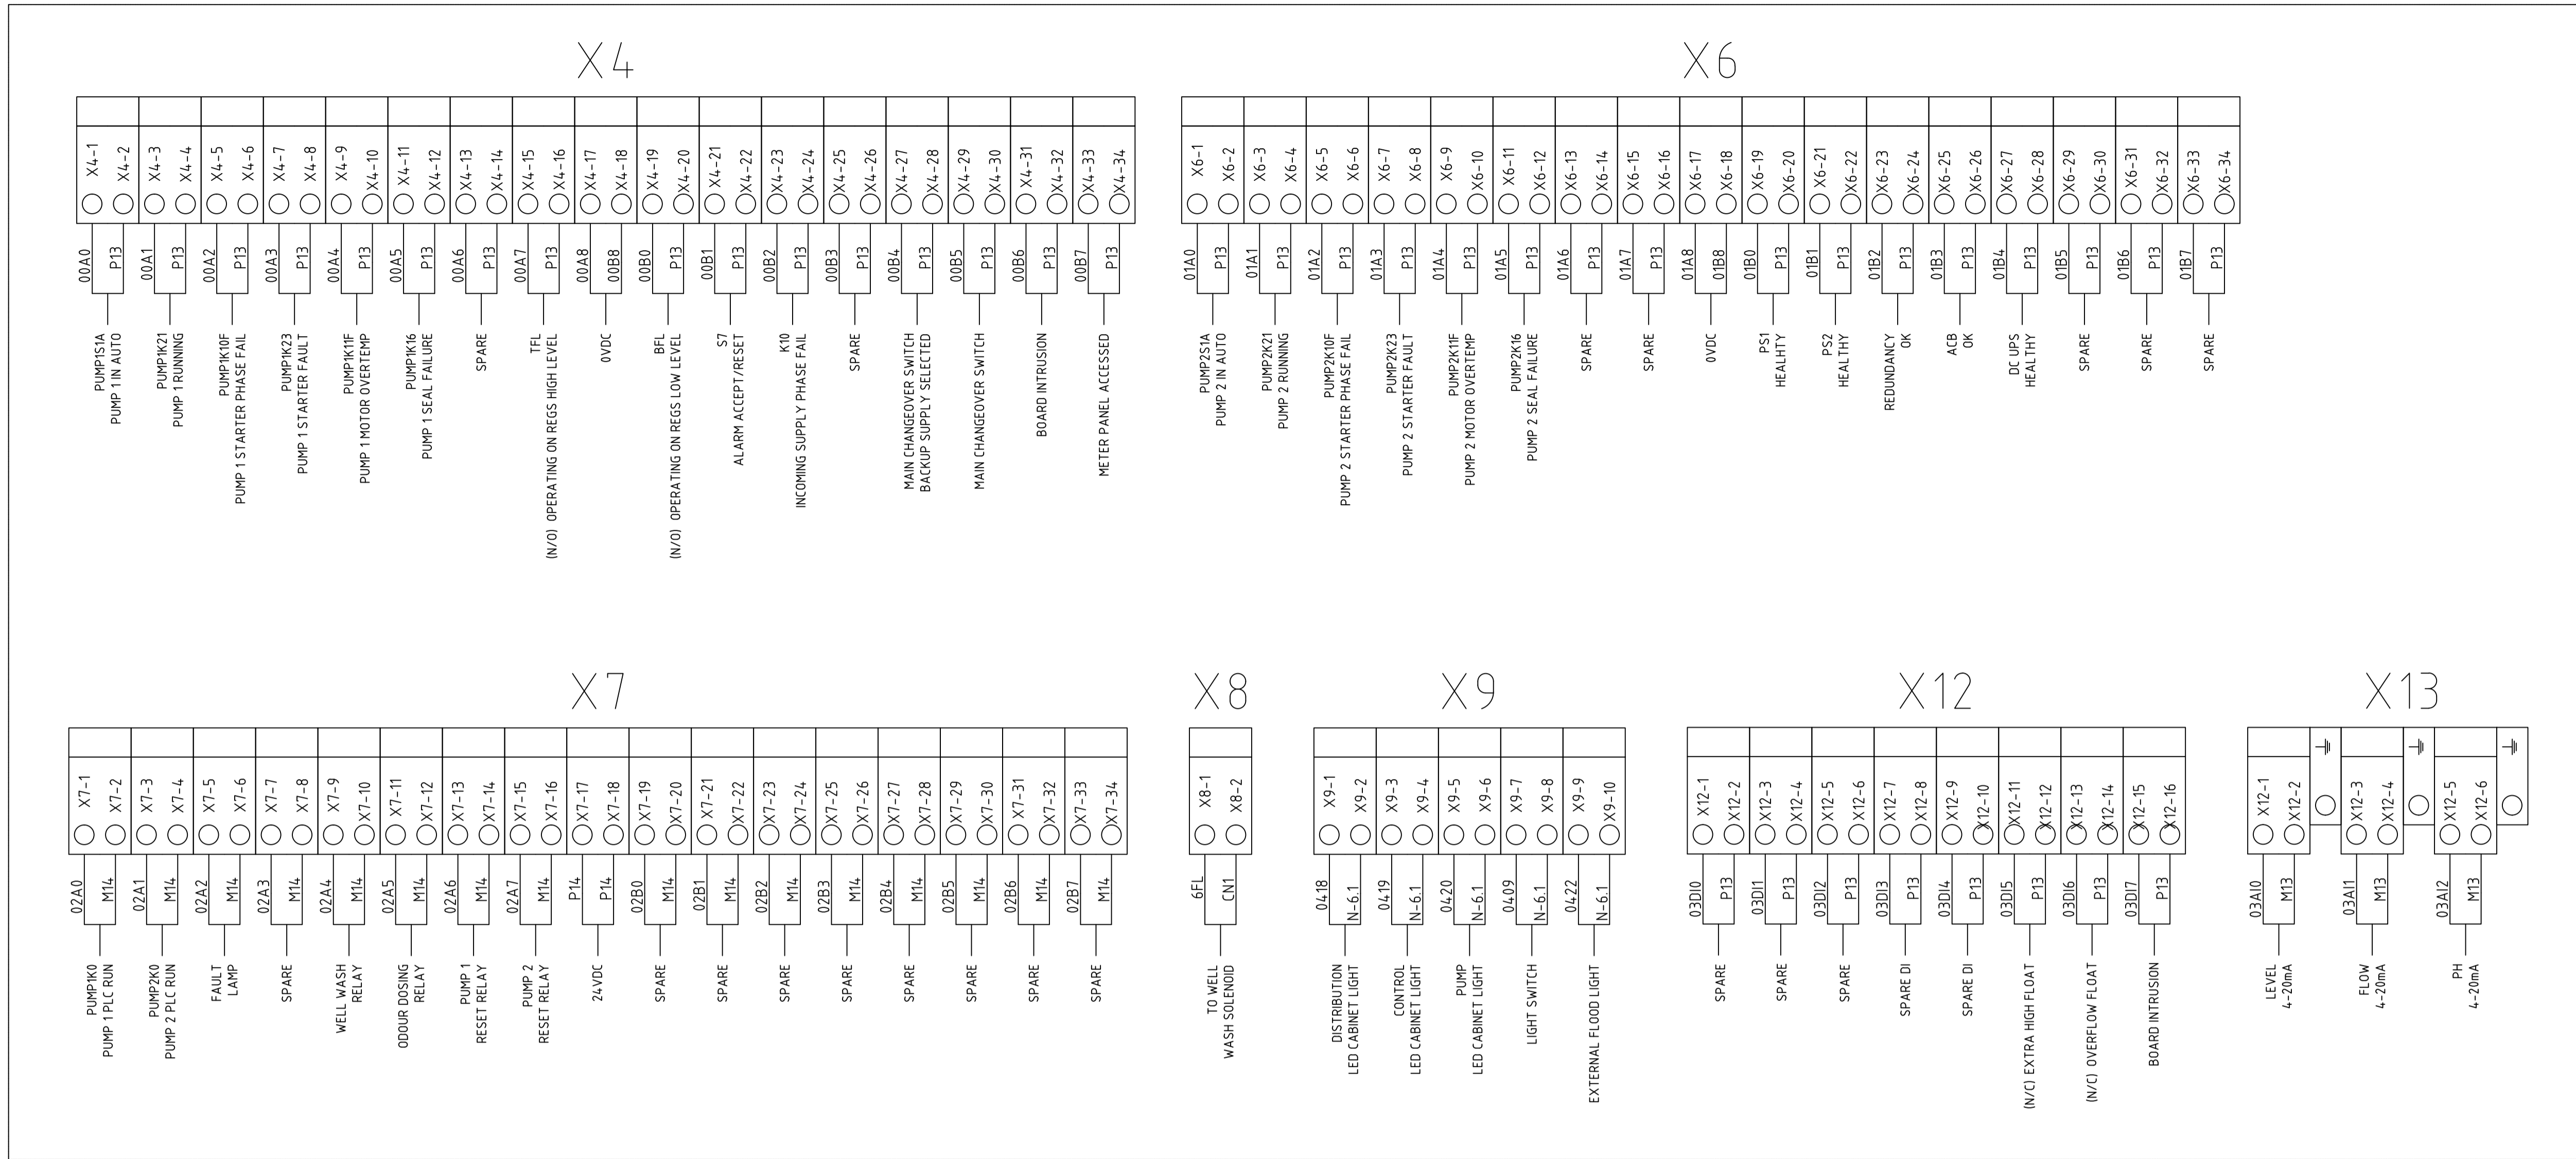

PUMP STARTER NO.1

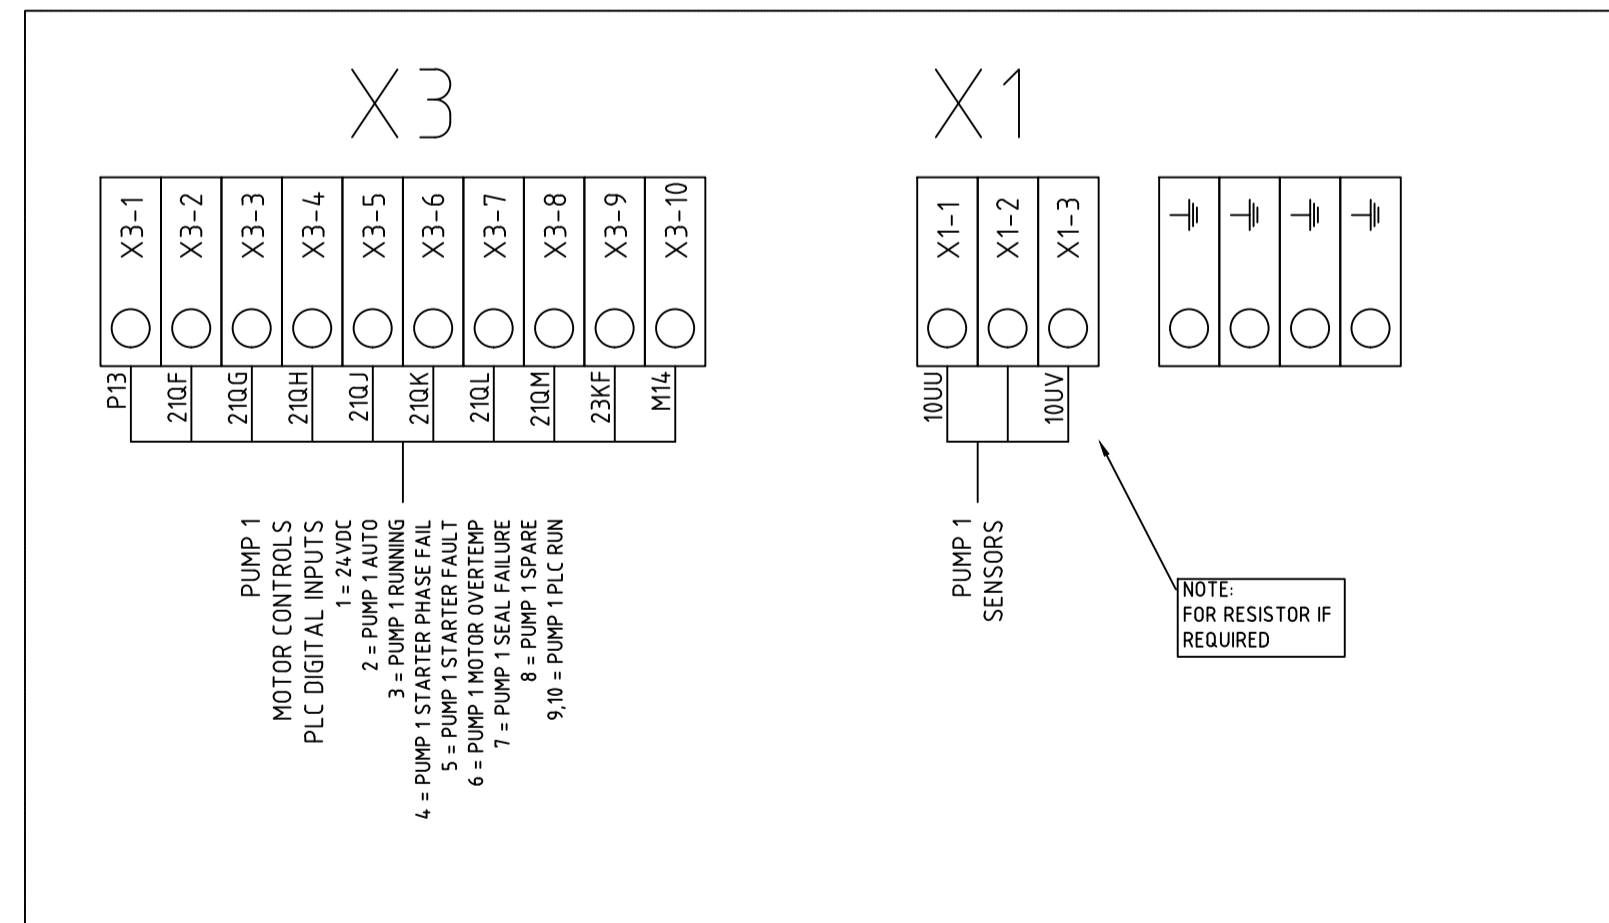

PUMP STARTER NO.2

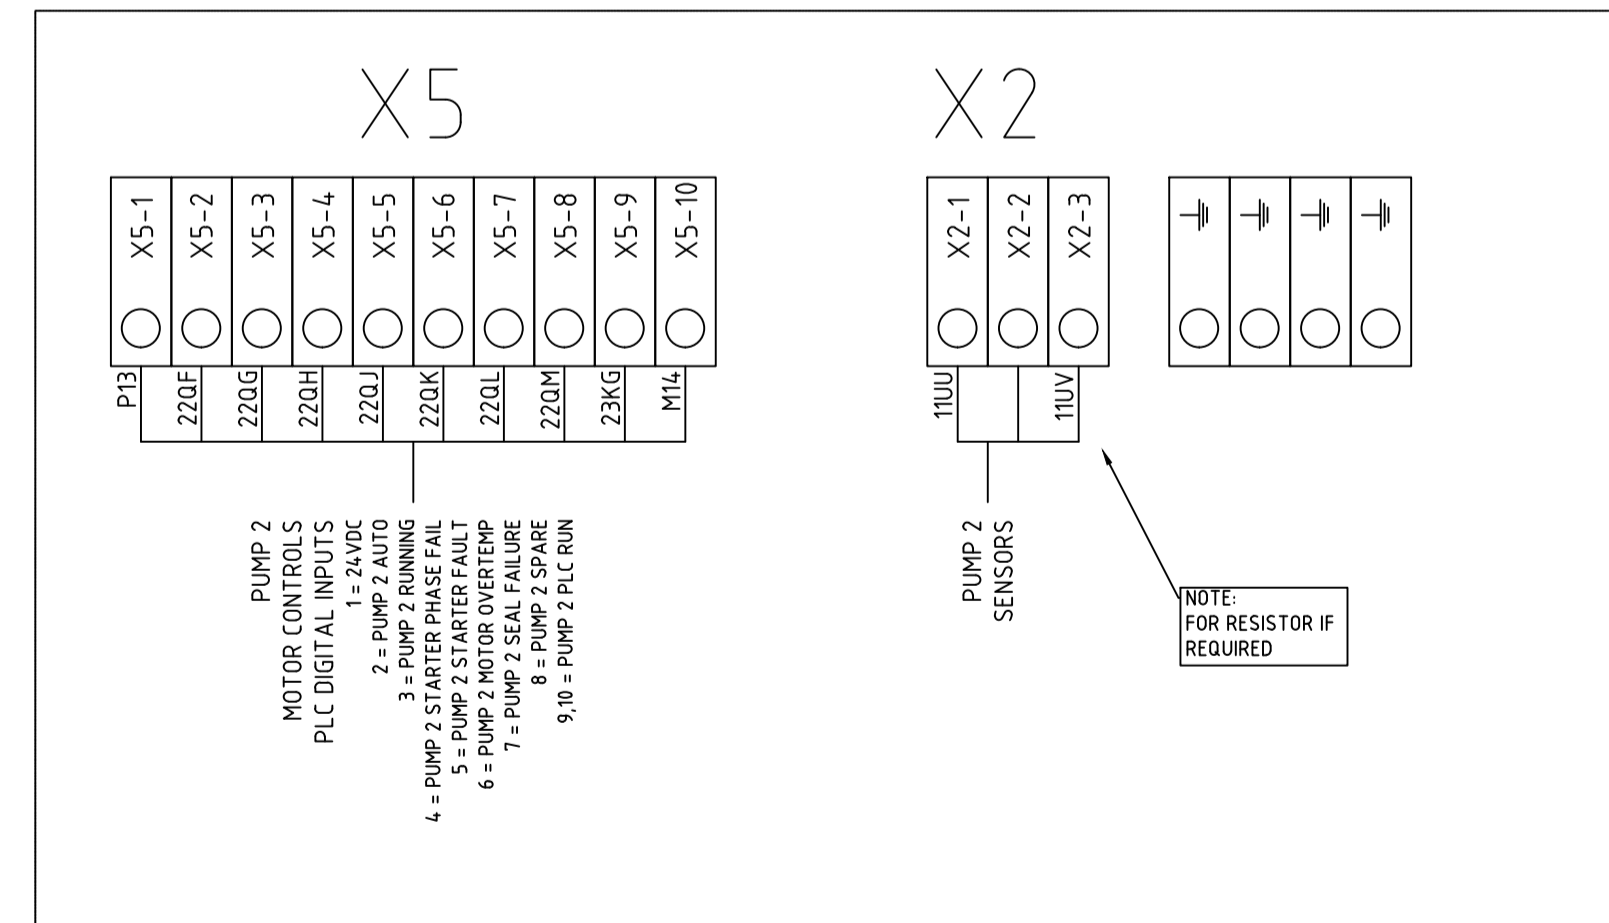

CABLE COLOURS		
Phases:	Red/White/Blue	
Neutral:	Black	
240VAC:	White	
12/24VDC:	Blue&Red	Blue&White
12/24VAC:	Brown&Red	Brown&White
MINIMUM CABLE SIZES		
Power:	2.5mm ²	
Control:	0.75mm ²	
Instrumentation:	0.5mm ²	

CONSULTANT DETAILS:

SIZE: A1 SCALE FACTOR: N.T.S. CO-ORDINATE SYSTEM: MGA 2020 Zone 56 HEIGHT DATUM: AHD





SURVEYED:	DATE:	COMPANY:
DESIGNED:	DATE:	COMPANY:
DRAWN:	DATE:	COMPANY:
CHECKED:	DATE:	COMPANY:
APPROVED:	DATE:	COMPANY:

TITLE:
**SMALL SPS SCA PANEL (TYPICAL)
ELECTRICAL SCHEMATIC
TERMINAL STRIP
CONNECTION DIAGRAM**

TRIM REFERENCE No	INDEX No.	DRAWING No.	SHEET	REV No.
47662E	23557	12	12	0

Plotted: 19/09/24 - 13:57 CAD File: C:\Users\grace.johns\OneDrive - Shoalhaven City Council\2. Current Projects\Electrical Drawing Updates - Craig Ellis\uploads to website\47552 - 23557 - SMALL SPS (TYPICAL) SCHEMATICS.dwg

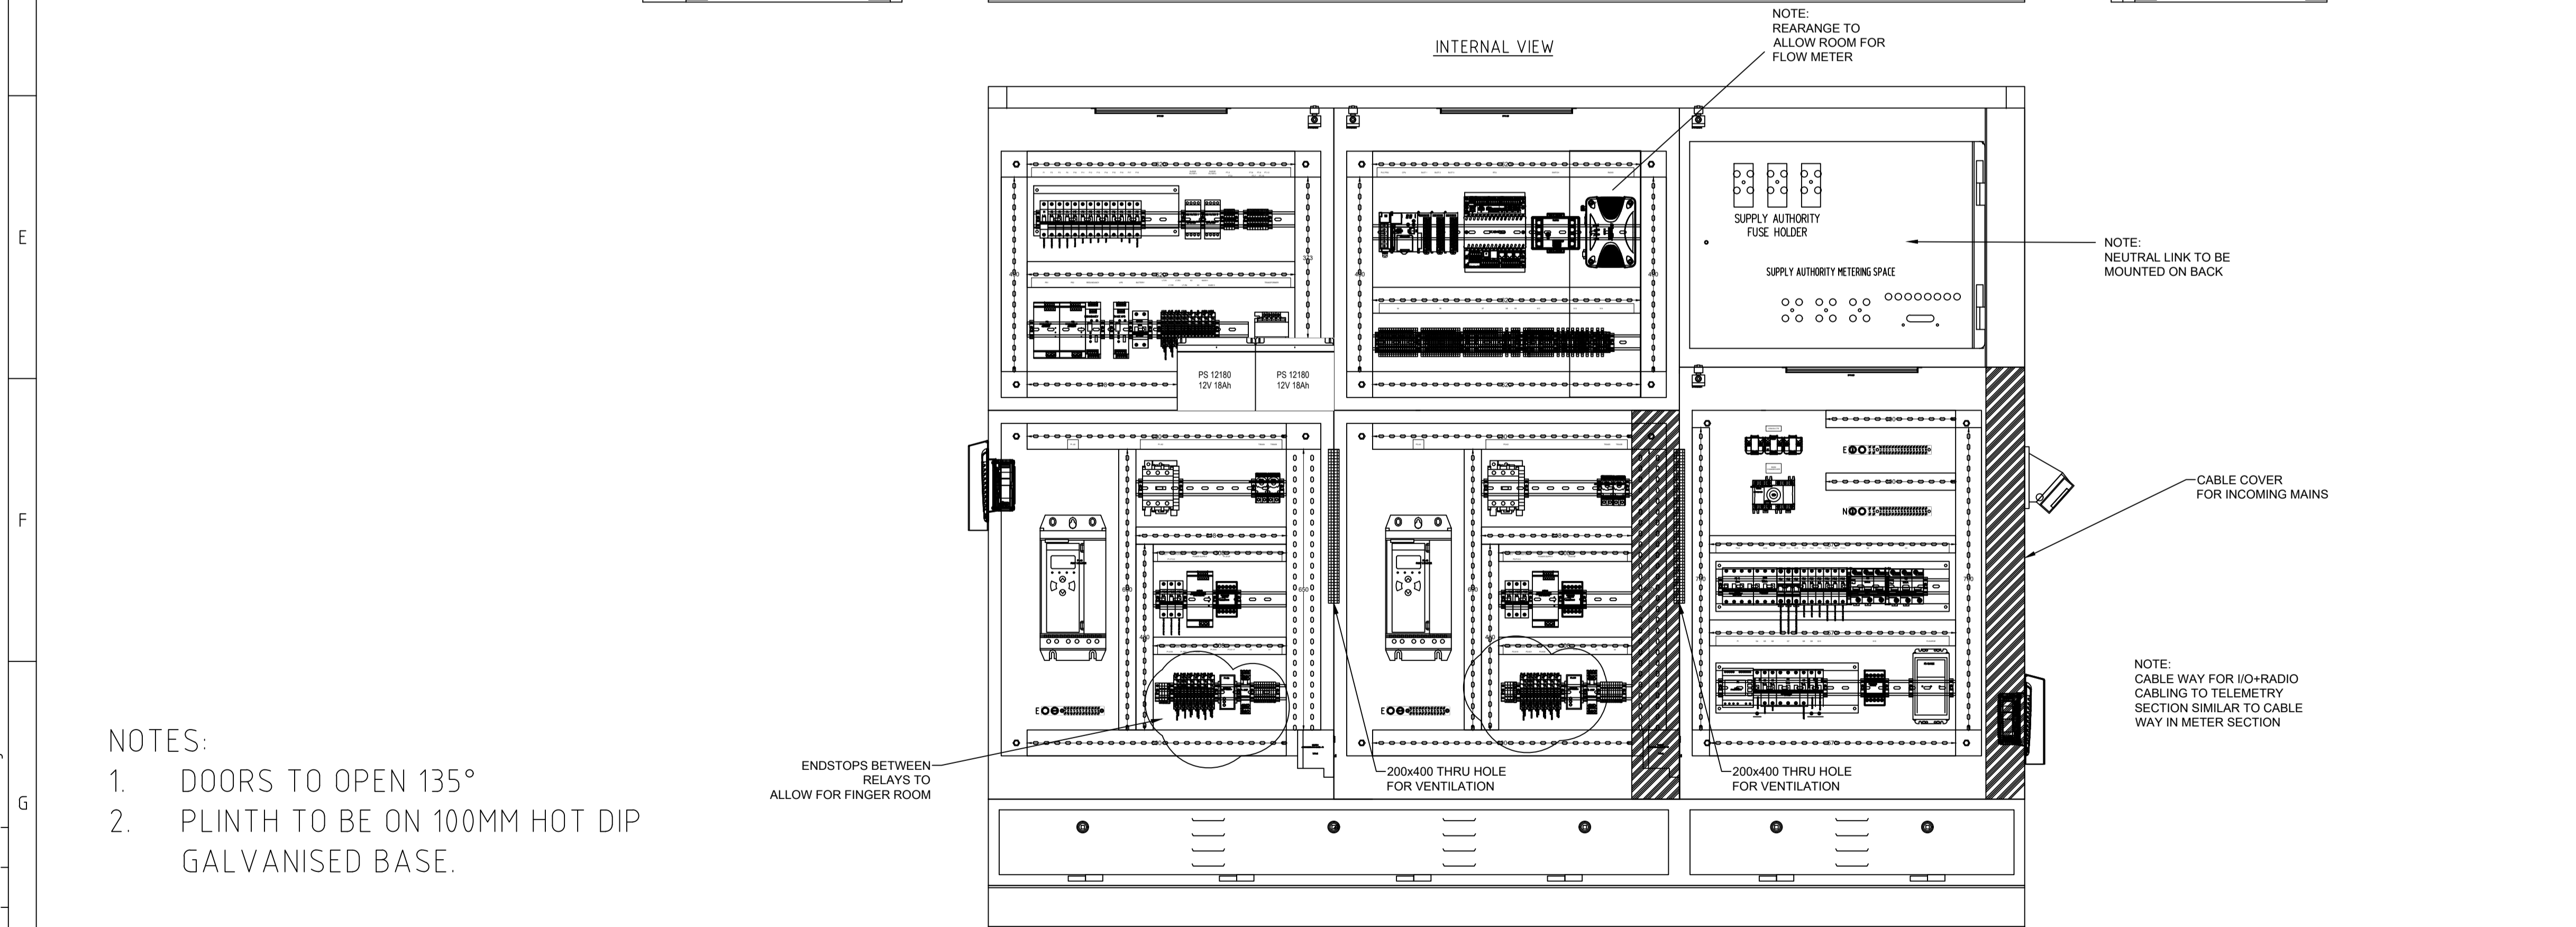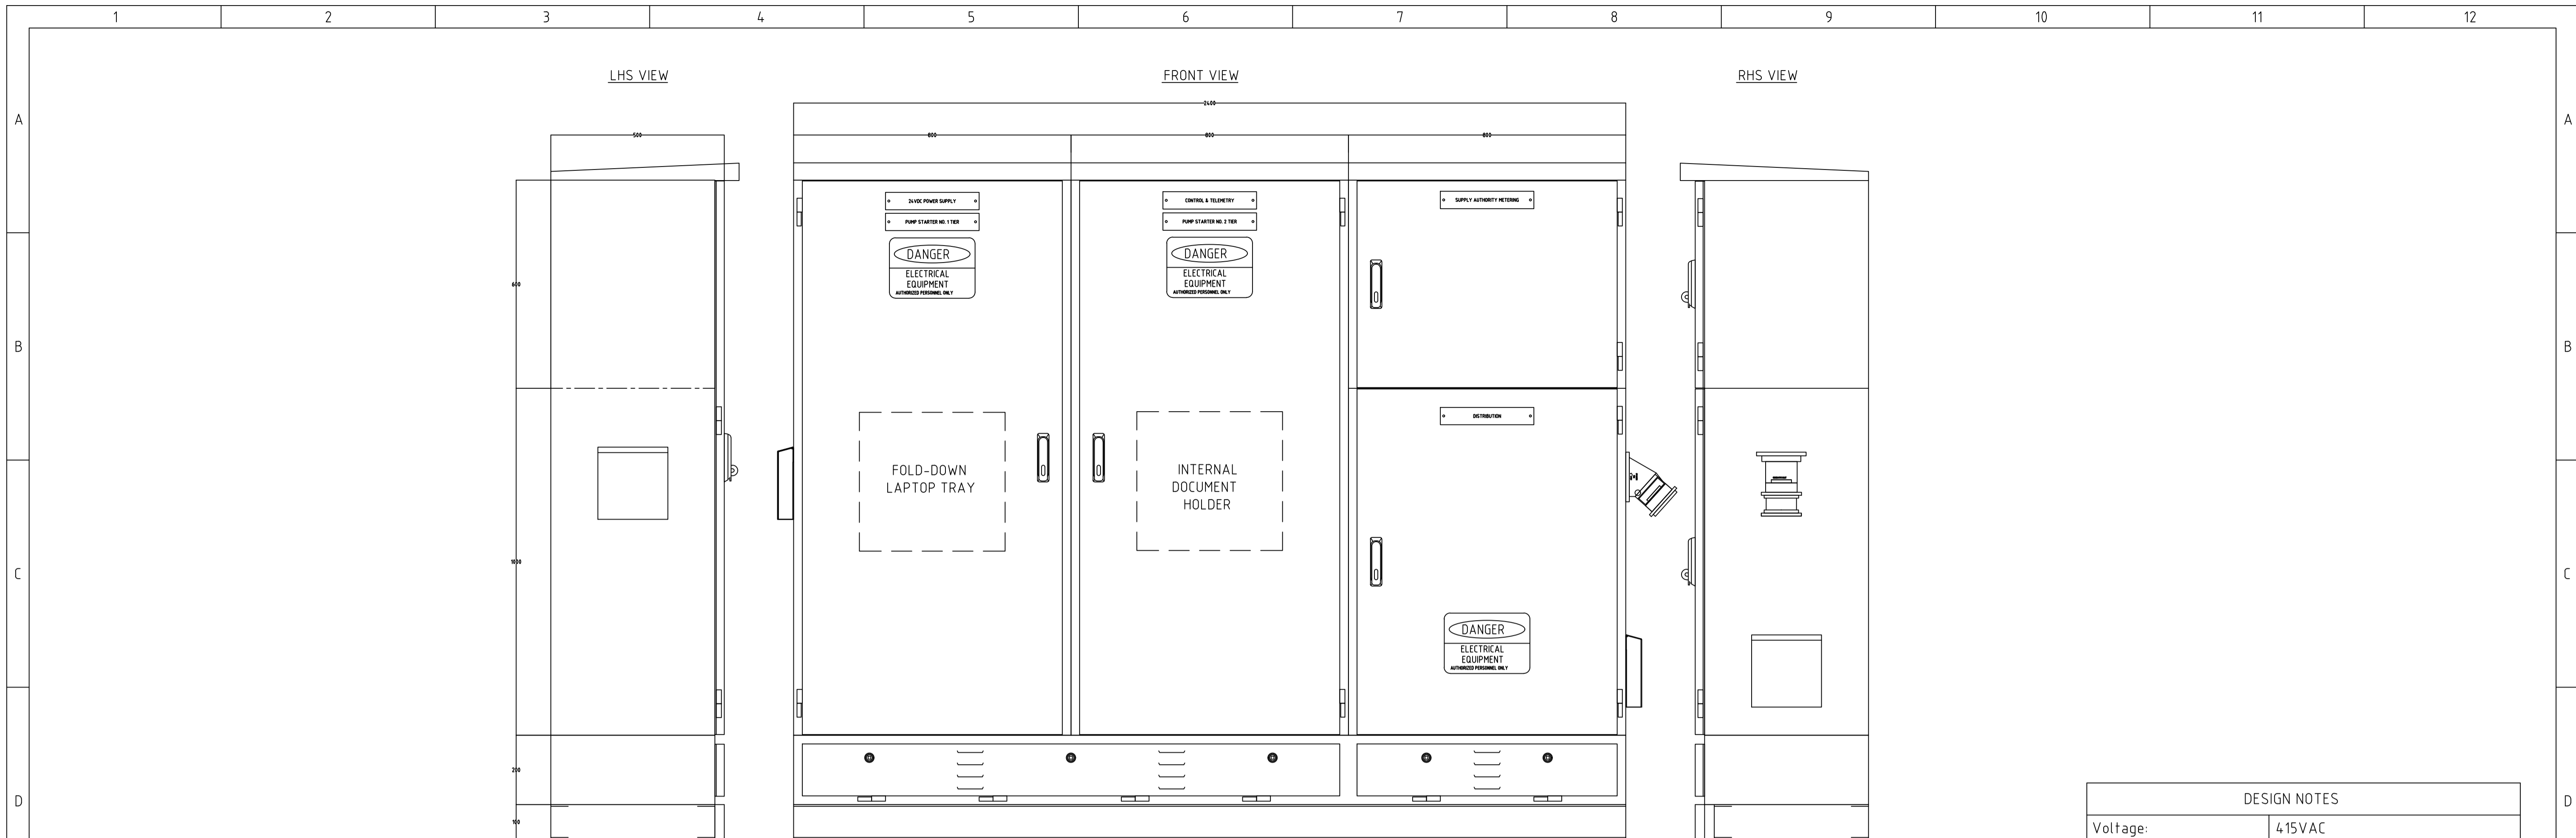


- NOTES:
- DOORS TO OPEN 135°
 - PLINTH TO BE ON 100MM HOT DIP GALVANISED BASE.

DESIGN NOTES		
Voltage:	415VAC	
Current Rating:	125A	
Short Circuit Rating:	6kA	
IP Rating:	IP56	
Form Rating:	Form 3bih	
Design Temp:	0-40°C	
CONSTRUCTION NOTES		
ENCLOSURE		
External Material:	2.0mm 316SS	
Mounting Panel Material:	2.0mm 316SS	
External Colour:	G54 Mist Green	
Mounting Panel, Escutcheon Colour:	N14 White	
Cable Entry:	Bottom	
Gland Plate Material:	6mm Aluminum	
LABELLING		
External Material:	Traffolyte (04mm)	
Internal Material:	Traffolyte (04mm)	
CABLE COLOURS		
Phases:	R/W/B	
Neutral:	Black	
240VAC:	White	
12/24 VDC:	Blue&Red	Blue&White
24VAC:	Brown&Red	Brown&White
ANALOGUE:	White	Black
MINIMUM CABLE SIZES		
Power:	2.5mm ²	
Control:	0.75mm ²	
Instrumentation:	0.5mm ²	

CONSULTANT DETAILS:						SURVEYED: DATE: COMPANY: DESIGNED: CE 15/02/24 COMPANY: SW DRAWN: GJ 04/06/24 COMPANY: SW CHECKED: AR 04/06/24 COMPANY: SW APPROVED: DATE: COMPANY:		TITLE: SMALL SPS SCA PANEL (TYPICAL) ELECTRICAL SCHEMATIC CONTROL PANEL - GENERAL LAYOUT EXTERNAL AND INTERNAL VIEW			
0 ISSUED FOR REVIEW GJ 04/06/24 No. REVISION DETAILS DWN DATE				SIZE: A1 SCALE FACTOR: N.T.S. CO-ORDINATE SYSTEM: MGA 2020 Zone 56 HEIGHT DATUM: AHD		City Administrative Centre PO Box 42, Nowra, NSW 2541 Ph 02 4429 3111 www.shoalwater.nsw.gov.au		TRIM REFERENCE No. 47662E INDEX No. 23557 DRAWING No. 13 SHEET 13 REV No. 0			

ESCUTCHEON VIEW

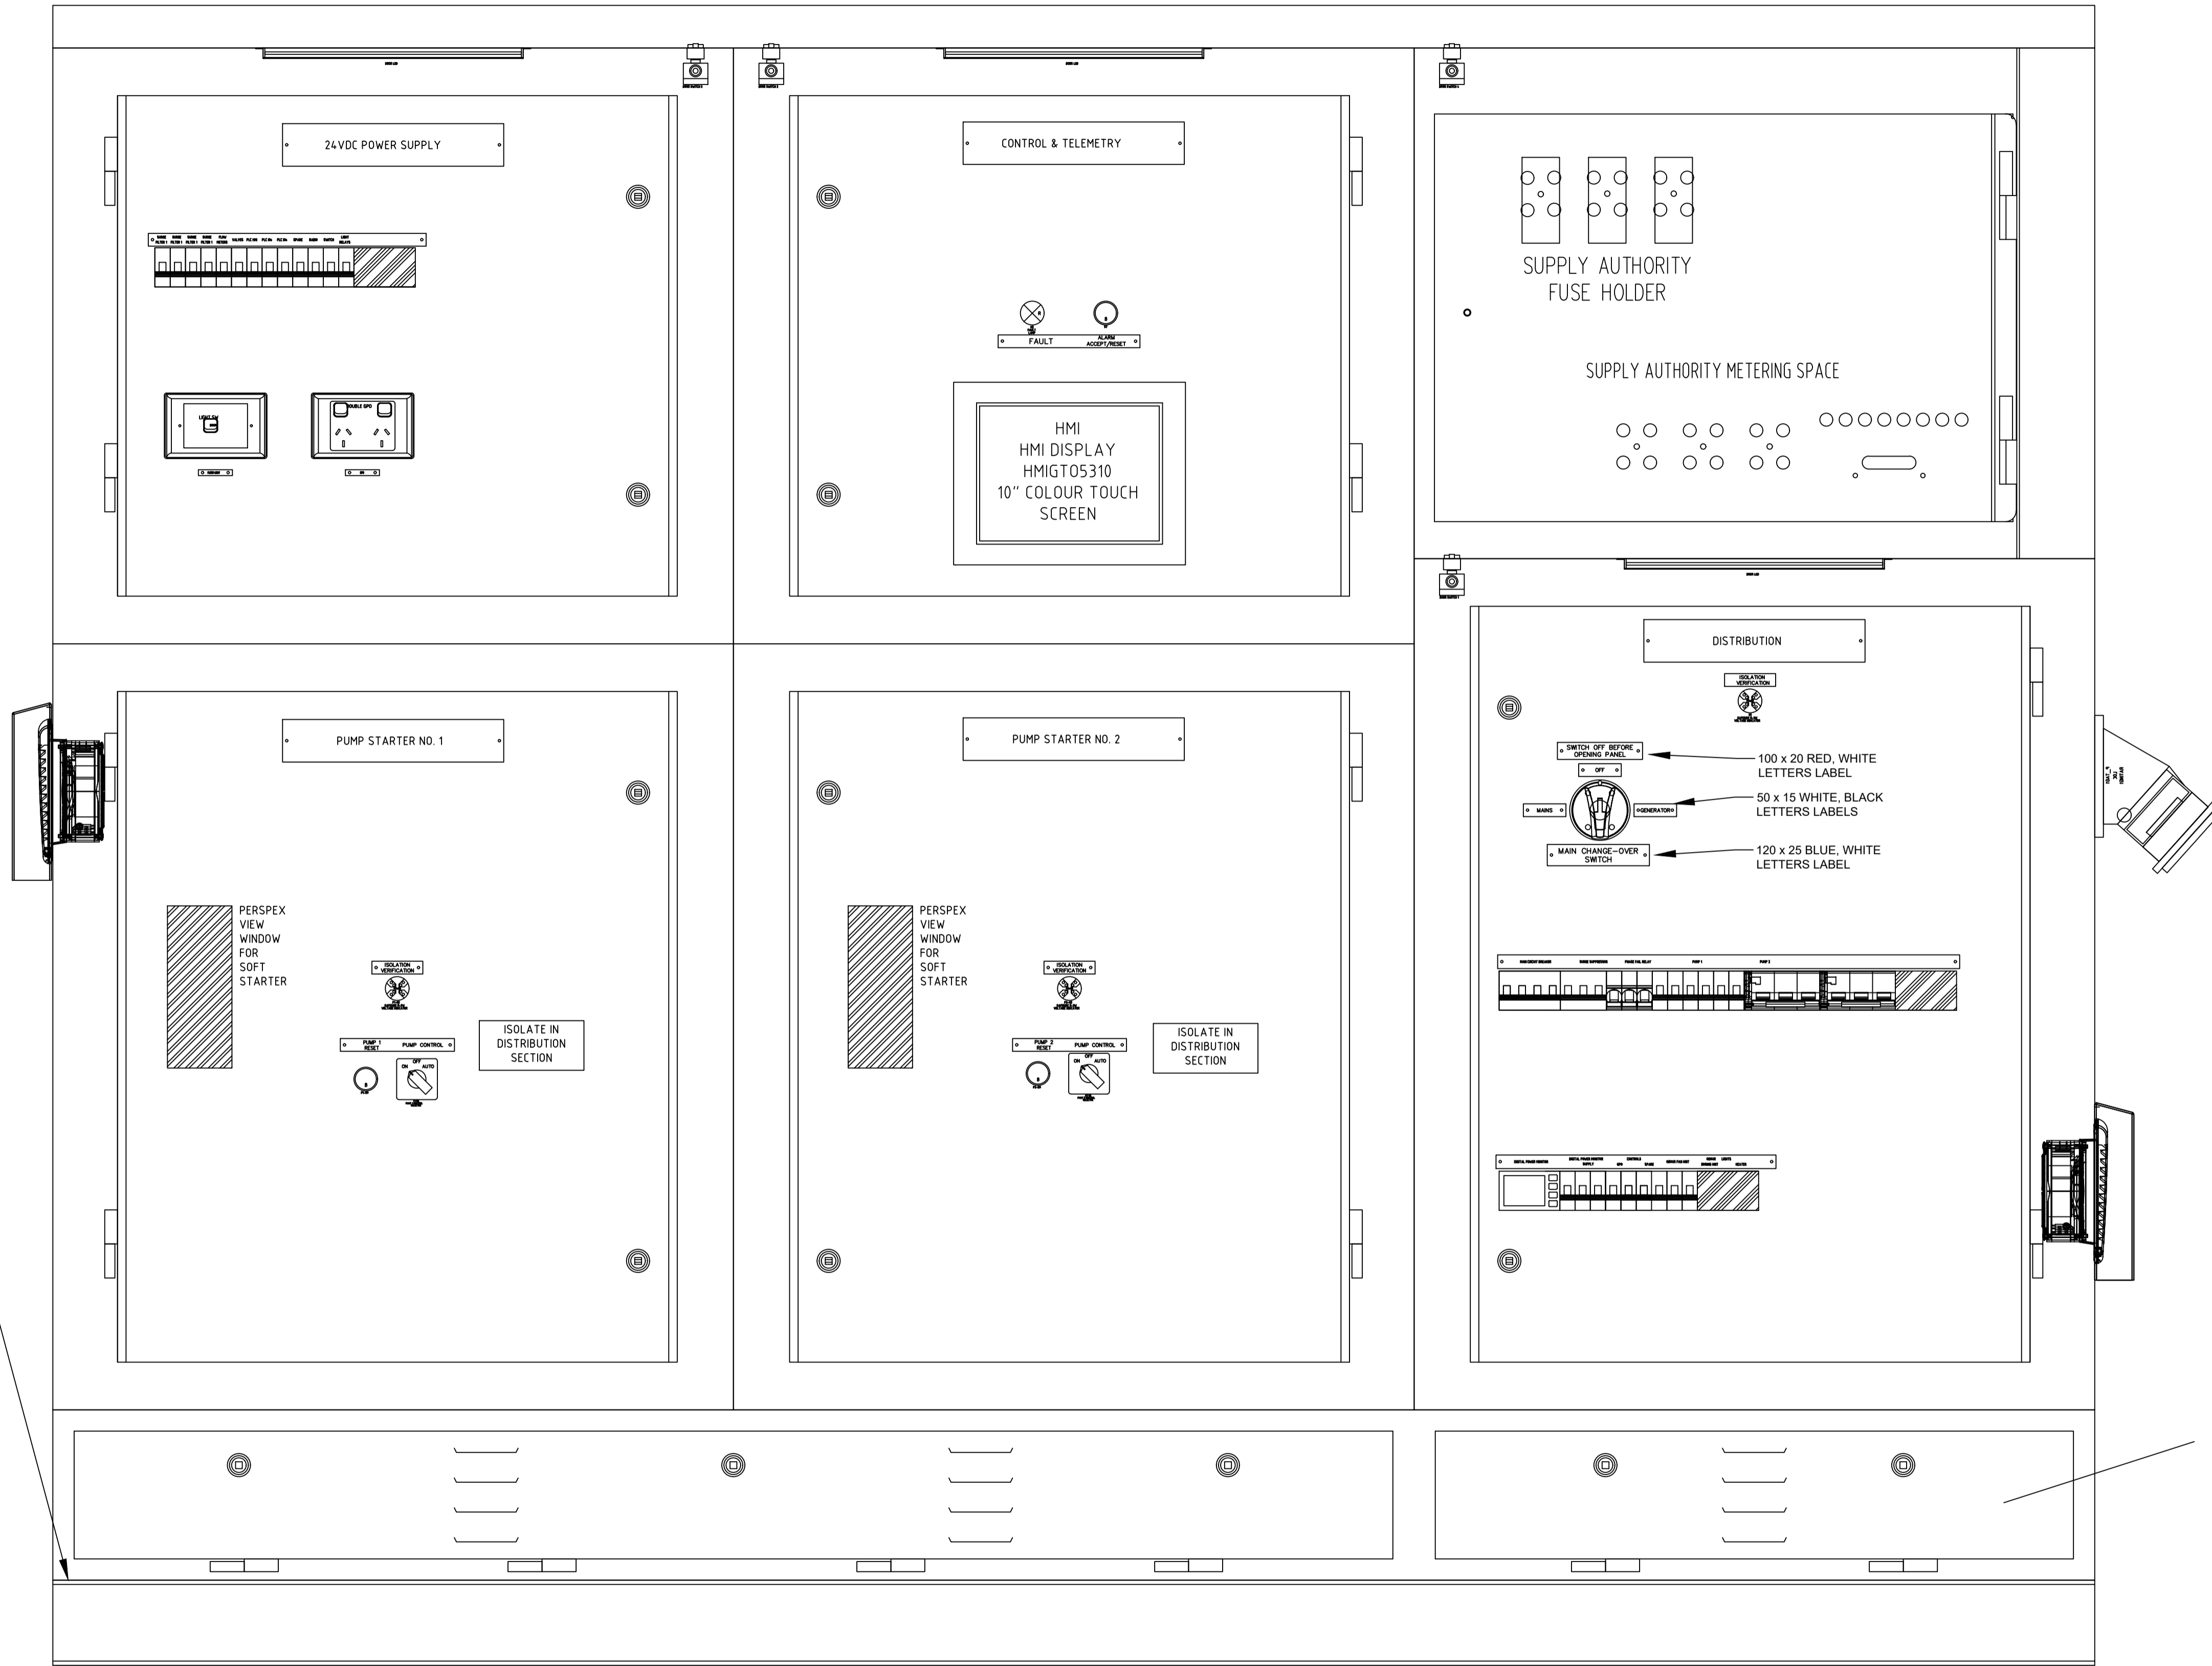


NOTE:
BOTTOM PLATE OPENING TO BE AS WIDE AS POSSIBLE TO ALLOW HANDS AND TOOLS TO BE REACHED INTO THE CABLE WAY TO MANIPULATE AND PULL CABLE AS WELL AS BOLT THE STEEL PLINTH C SECTION DOWN TO THE CONCRETE PLINT

NOTE:
CABLEWAY TO BE HOLLOW TO ALLOW FOR CABLE TRANSITION BETWEEN COMPARTMENTS

100 mm on original

				CONSULTANT DETAILS:		 City Administrative Centre PO Box 42, Nowra, NSW 2541 Ph 02 4429 3111 www.shoalwater.nsw.gov.au		SURVEYED: DATE: COMPANY: DESIGNED: CE DATE: 15/02/24 COMPANY: SW DRAWN: GJ DATE: 04/06/24 COMPANY: SW CHECKED: AR DATE: 04/06/24 COMPANY: SW APPROVED: DATE: COMPANY:		TITLE: SMALL SPS SCA PANEL (TYPICAL) ELECTRICAL SCHEMATIC CONTROL PANEL - GENERAL LAYOUT ESCUTCHEON VIEW			
0 ISSUED FOR REVIEW		GJ	04/06/24	SIZE: A1	SCALE FACTOR: N.T.S.	CO-ORDINATE SYSTEM: MGA 2020 Zone 56	HEIGHT DATUM: AHD	TRIM REFERENCE No: 47662E	INDEX No: 23557	DRAWING No: 14	SHEET: 14	REV No: 0	
REVISION DETAILS		DWN	DATE										

EQUIPMENT LIST			
ITEM	BRAND	MODEL	DESCRIPTION
1	CROMPTON		R13 DIGITAL METERING SYSTEM
2	SCHNEIDER	METSECT5CC010	CURRENT TRANSFORMER 100-5A DIN RAIL
3		420032	FUSE 38x10 32A 120kA
4	ERICO	TDX100C277480	SURGE SUPPRESSOR 100kA
5	SCHNEIDER	A9F44316	MCB 16A 6kA 3P
6	SCHNEIDER	A9F44116	MCB 16A 6kA 1P
7	SCHNEIDER	A9F44110	MCB 10A 6kA 1P
8	SCHNEIDER	A9F44106	MCB 6A 6kA 1P
9	SCHNEIDER	A9F44104	MCB 4A 6kA 1P
10	SCHNEIDER	A9F44102	MCB 2A 6kA 1P
11	ATC	G79242	THERMISTOR RELAY 24VDC
12	PROCONNECT	3PS9A3NE01	GENERATOR INLET 150A 3P+N+E
13	SCHNEIDER	A9N18514	MCB 125A 4P D CURVE 108MM WIDE
14	SAFESADE	R-3W2	VOLTAGE INDICATOR
15	SOCOME	SLBM1253PD	ISOLATOR DIRECT HANDLE 125A 3P DIN RAIL MOUNT
16	SCHNEIDER	A9N18367	MCB 100A 3P 10kA
17	CROMPTON		AMMETER DIRECT 0-10A 5X OVERSCALE 72MM
18	SCHNEIDER	METSECT5CC008	CURRENT TRANSFORMER 75-5A DIN RAIL
19	DANFOSS	136G8765	MCD600 SOFT STARTER 63A
20	SCHNEIDER	A9D61820	RCBO 20A 1P 30mA 6kA CHASSIS
21	SCHNEIDER	A9D61810	RCBO 10A 1P 30mA 6kA CHASSIS
22	SCHNEIDER	A9D61806	RCBO 6A 1P 30mA 6kA CHASSIS
23	CLIPSAL	2025XA	DOUBLE GPO WITH LIGHT SWITCH
24	SUNNY	SALSL9706/540TC	LED STRIP CABINET LIGHT 540mm 9W 240VA FLEX & PLUG
25	SCHNEIDER	NSYCC0TH0	THERMOSTAT COOLING 1NO
26	SCHNEIDER	NSYCR50WU2C	HEATER 50W 240V
27	ERICO	DSF-6A-275V	SURGE FILTER 1P 6A 240V DIN RAIL
28	SCHNEIDER	ABL6TS06B	TRANSFORMER 415/240-24VAC 60VA
29	PHOENIX	1AC/24DC/10	QUINT POWER SUPPLY 10A
30	PHOENIX	2320173	QUINT-ORING/24DC/2X10/1X20 POWER SUPPLY 2x10A In, 1x20A Out
31	SCHNEIDER	XB4BVB4	INDICATOR 24V RED
32	SCHNEIDER	RXG12BD	RELAY 24VDC COIL 1CO LED
33	K&N	CA10 A710 FT2 AUS0049	SWITCH 3POS ON OFF AUTO 2X1P 48MM
34	FLYGT	MINICAS	MINICAS RELAY
35	SCHNEIDER	ZB4BA6	PUSHBUTTON HEAD BLUE
36	OMRON	CJ1W-PD022	PLC POWER SUPPLY 24VDC
37	OMRON	CJ2M-CPU31	PLC CPU
38	OMRON	CJ1W-ID211	PLC MODULE 16DI
39	OMRON	CJ1W-OC211	PLC MODULE 16DO
40	OMRON	CJ1W-TER01	PLC RACK END COVER
41	OMRON	CP1W-MODTCP61	MODBUS TCP ADAPTER
42	SCHNEIDER	HMIGT05310	HMI 10.4" COLOUR IP65 ETHERNET USB 640x480 PIX
43	SCHNEIDER	SCADAPACK 334E	RTU 334E 16DI 8AI 10DO
44	WEIDMULLER	1020100000	TERMINAL WDU4.0 BEIGE 4MM2 DIN RAIL
45	WEIDMULLER	1020080000	TERMINAL WDU2.5 BLUE 2.5MM2 DIN RAIL
46	WEIDMULLER	1021580000	TERMINAL 2.5MM BLUE DOUBLE DECK
47	WEIDMULLER	1010000000	EARTH TERMINAL WPE 2.5MM2 DIN RAIL
48	WEIDMULLER	8731640000	DISCONNECT TERMINAL WTR2.5 BLUE
49	WEIDMULLER	1579000000	24-WAY JUMPER TO SUIT WDK 2.5 TERMINALS
50	DF ELECTIC	420032	FUSE 38x10 32A 120kA
51	RS PRO	902-6865	LIMIT SWITCH ADJUSTABLE SIDE ROLLER LEVER IP65 M20
52	CLIPSAL	2031VA-WE	LIGHT SWITCH WALL PLATE WHITE

CONSULTANT DETAILS:				 City Administrative Centre PO Box 42, Nowra, NSW 2541 Ph 02 4429 3111 www.shoalwater.nsw.gov.au		SURVEYED: _____ DATE: _____ COMPANY: _____		TITLE: SMALL SPS SCA PANEL (TYPICAL) ELECTRICAL SCHEMATIC EQUIPMENT LIST							
						DESIGNED: CE DATE: 15/02/24 COMPANY: SW									
						DRAWN: GJ DATE: 04/06/24 COMPANY: SW									
						CHECKED: AR DATE: 04/06/24 COMPANY: SW									
				APPROVED: _____ DATE: _____ COMPANY: _____		TRIM REFERENCE No. 47662E		INDEX No. 23557		DRAWING No. 15		SHEET 15		REV No. 0	
0 ISSUED FOR REVIEW		GJ 04/06/24		SIZE: A1	SCALE FACTOR: N.T.S.	CO-ORDINATE SYSTEM: MGA 2020 Zone 56									
REVISION DETAILS		DWN DATE													